 


KEY LEGEND

- ⊖ DUPLEX RECEPTACLE
- ⊖ DUPLEX RECEPTACLE TOP HALF SWITCHED
- ⊖ GF DUPLEX RECEPTACLE GROUND FAULT
- ⊖ FLOOR DUPLEX RECEPTACLE
- ⊖ R RANGE RECEPTACLE
- ⊖ M MICROWAVE RECEPTACLE
- ⊖ W WASHER RECEPTACLE
- ⊖ D DRYER RECEPTACLE
- ⊖ * DUPLEX RECEPTACLE ABOVE COUNTER
- ⊖ J JUNCTION BOX
- ⊖ TD TELEPHONE-DATA OUTLET
- ⊖ TV TELEVISION-DATA OUTLET
- ⊖ T1 TELEPHONE OUTLET
- ⊖ DB DOOR BELL-INTERIOR
- DB DOOR BELL
- ▭ RECESSED LOW VOLTAGE PANEL
- ▭ RECESSED ELECTRICAL PANEL
- S WALL SWITCH
- S₃ THREE-WAY SWITCH
- S_{3D} THREE-WAY DIMMER SWITCH
- CPT. CARPET
- LVT. LUXURY VINYL TILE

MERRITT - UNIT 103 FLOOR PLAN

SCALE: 3/16"=1'-0"



SEARSTONE
RETIREMENT COMMUNITY


APPROVED:
DATE:

MERRITT




 

 


 

 


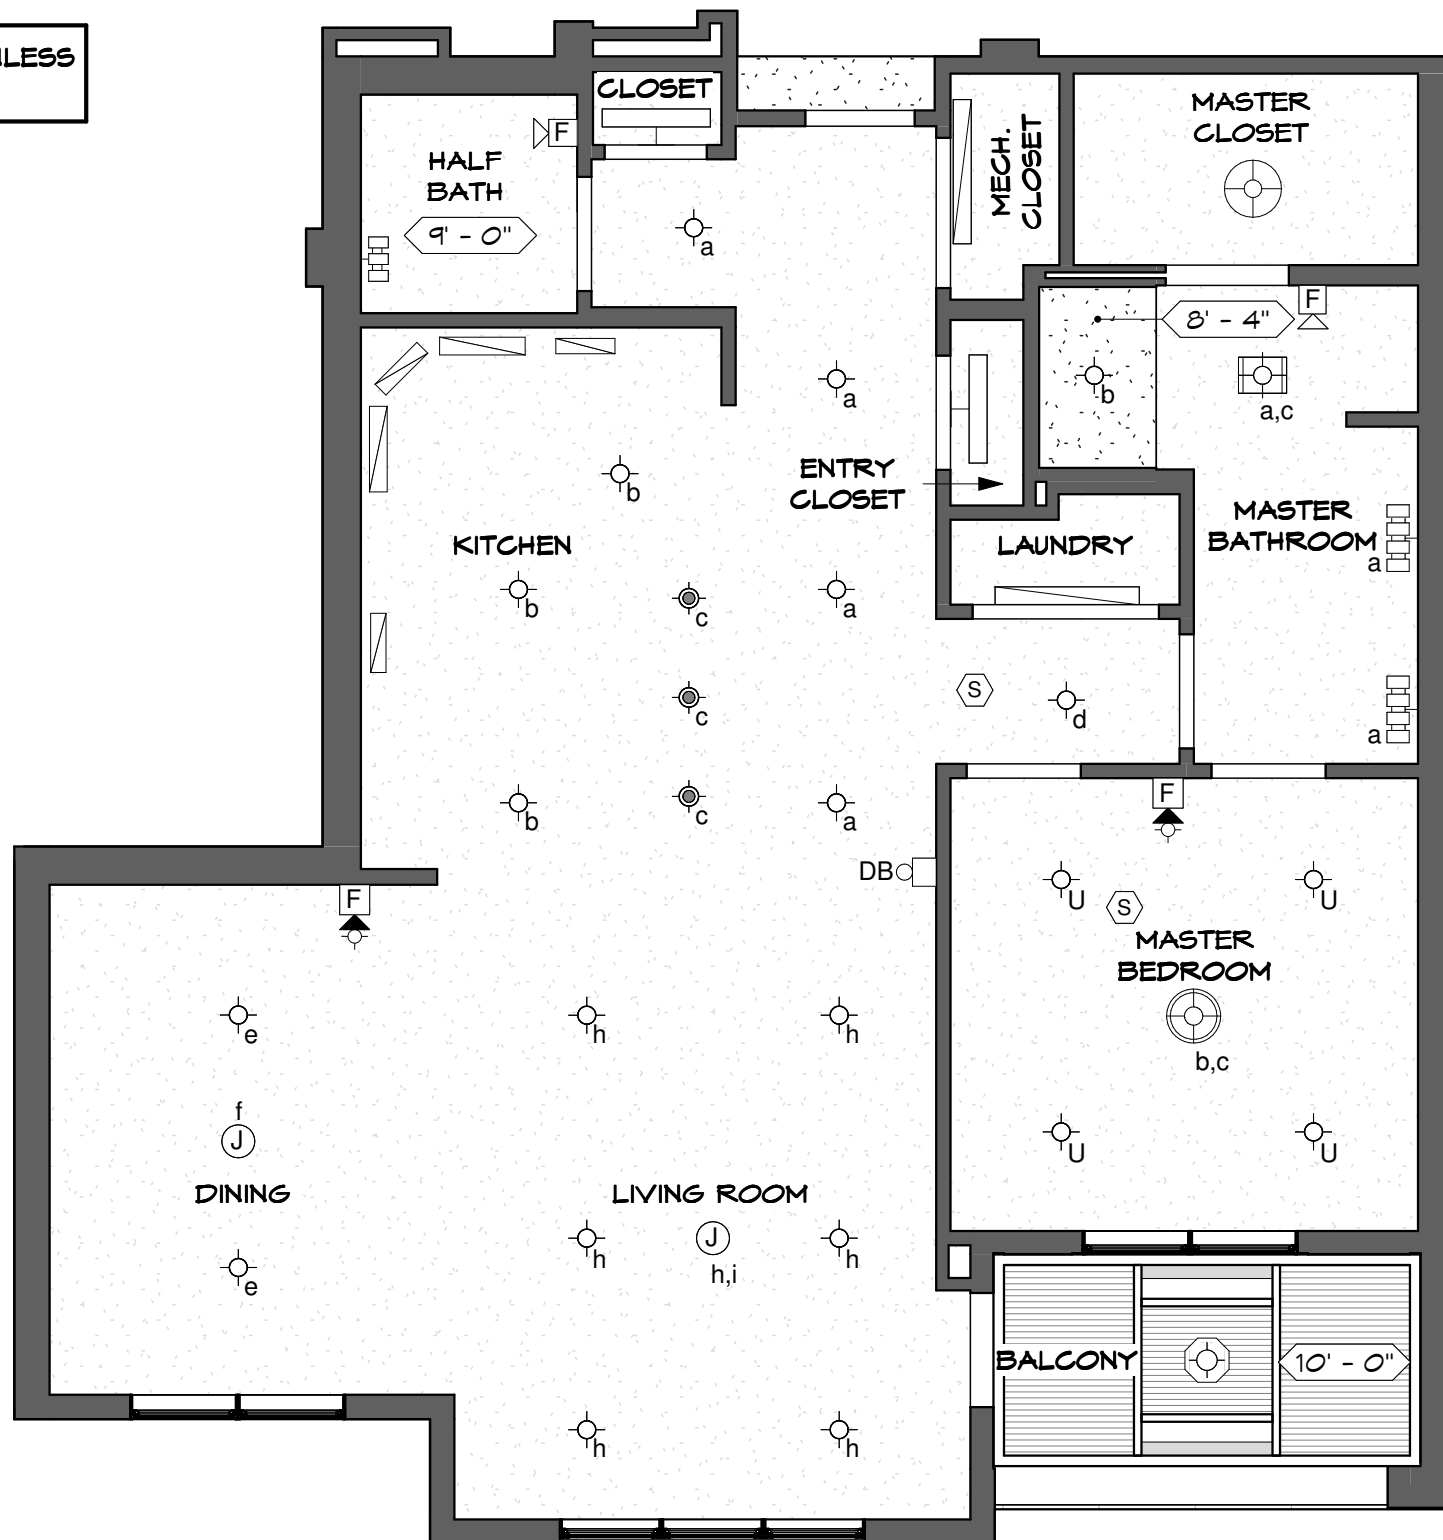
 
 
 
 
*FLOOR PLAN
SUBJECT TO CHANGE

SHEET 1 OF 2

10'-0" CEILING HEIGHT UNLESS NOTED OTHERWISE



KEY LEGEND

-  JUNCTION BOX
-  SMOKE DETECTOR
-  4" DIAM. SHOWER LIGHT FIXTURE
-  6" DIAM. SURFACE MOUNTED LIGHT FIXTURE
-  6.5" DIAM. PENDANT LIGHT FIXTURE
-  18" DIAM. PENDANT LIGHT FIXTURE
-  19" DIAM. PENDANT LIGHT FIXTURE
-  COMBINATION LIGHT/HEATER/FAN
-  COMBINATION LIGHT/FAN
-  VANITY LIGHT BAR (3)
-  VANITY LIGHT BAR (4)
-  UNDERCABINET LIGHT FIXTURE
-  36" TROFFER LIGHT FIXTURE
-  48" TROFFER LIGHT FIXTURE
-  BALCONY LIGHT FIXTURE
-  UPGRADE - 6" DIAM. SURFACE MOUNTED LIGHT FIXTURE
-  FIRE ALARM AUDIO/VISUAL DEVICES
-  FIRE ALARM AUDIO DEVICE

MERRITT - UNIT 103 REFLECTED CEILING PLAN

SCALE: 3/16"=1'-0"



SEARSTONE
RETIREMENT COMMUNITY

APPROVED:
DATE:

MERRITT

*FLOOR PLAN
SUBJECT TO CHANGE

SHEET 2 OF 2