

















 





**KEY LEGEND**

-  DUPLEX RECEPTACLE
-  DUPLEX RECEPTACLE TOP HALF SWITCHED
-  GF DUPLEX RECEPTACLE GROUND FAULT
-  FLOOR DUPLEX RECEPTACLE
-  RANGE RECEPTACLE
-  MICROWAVE RECEPTACLE
-  WASHER RECEPTACLE
-  DRYER RECEPTACLE
-  DUPLEX RECEPTACLE ABOVE COUNTER
-  JUNCTION BOX
-  TELEPHONE-DATA OUTLET
-  TELEVISION-DATA OUTLET
-  TELEPHONE OUTLET
-  DOOR BELL-INTERIOR
-  DOOR BELL
-  RECESSED LOW VOLTAGE PANEL
-  RECESSED ELECTRICAL PANEL
-  WALL SWITCH
-  THREE-WAY SWITCH
-  THREE-WAY DIMMER SWITCH
-  CARPET
-  LUXURY VINYL TILE

**WOLFE II - UNIT 438 FLOOR PLAN**

SCALE: 3/16"=1'-0"



**SEARSTONE**  
RETIREMENT COMMUNITY


APPROVED:  
DATE:

WOLFE II







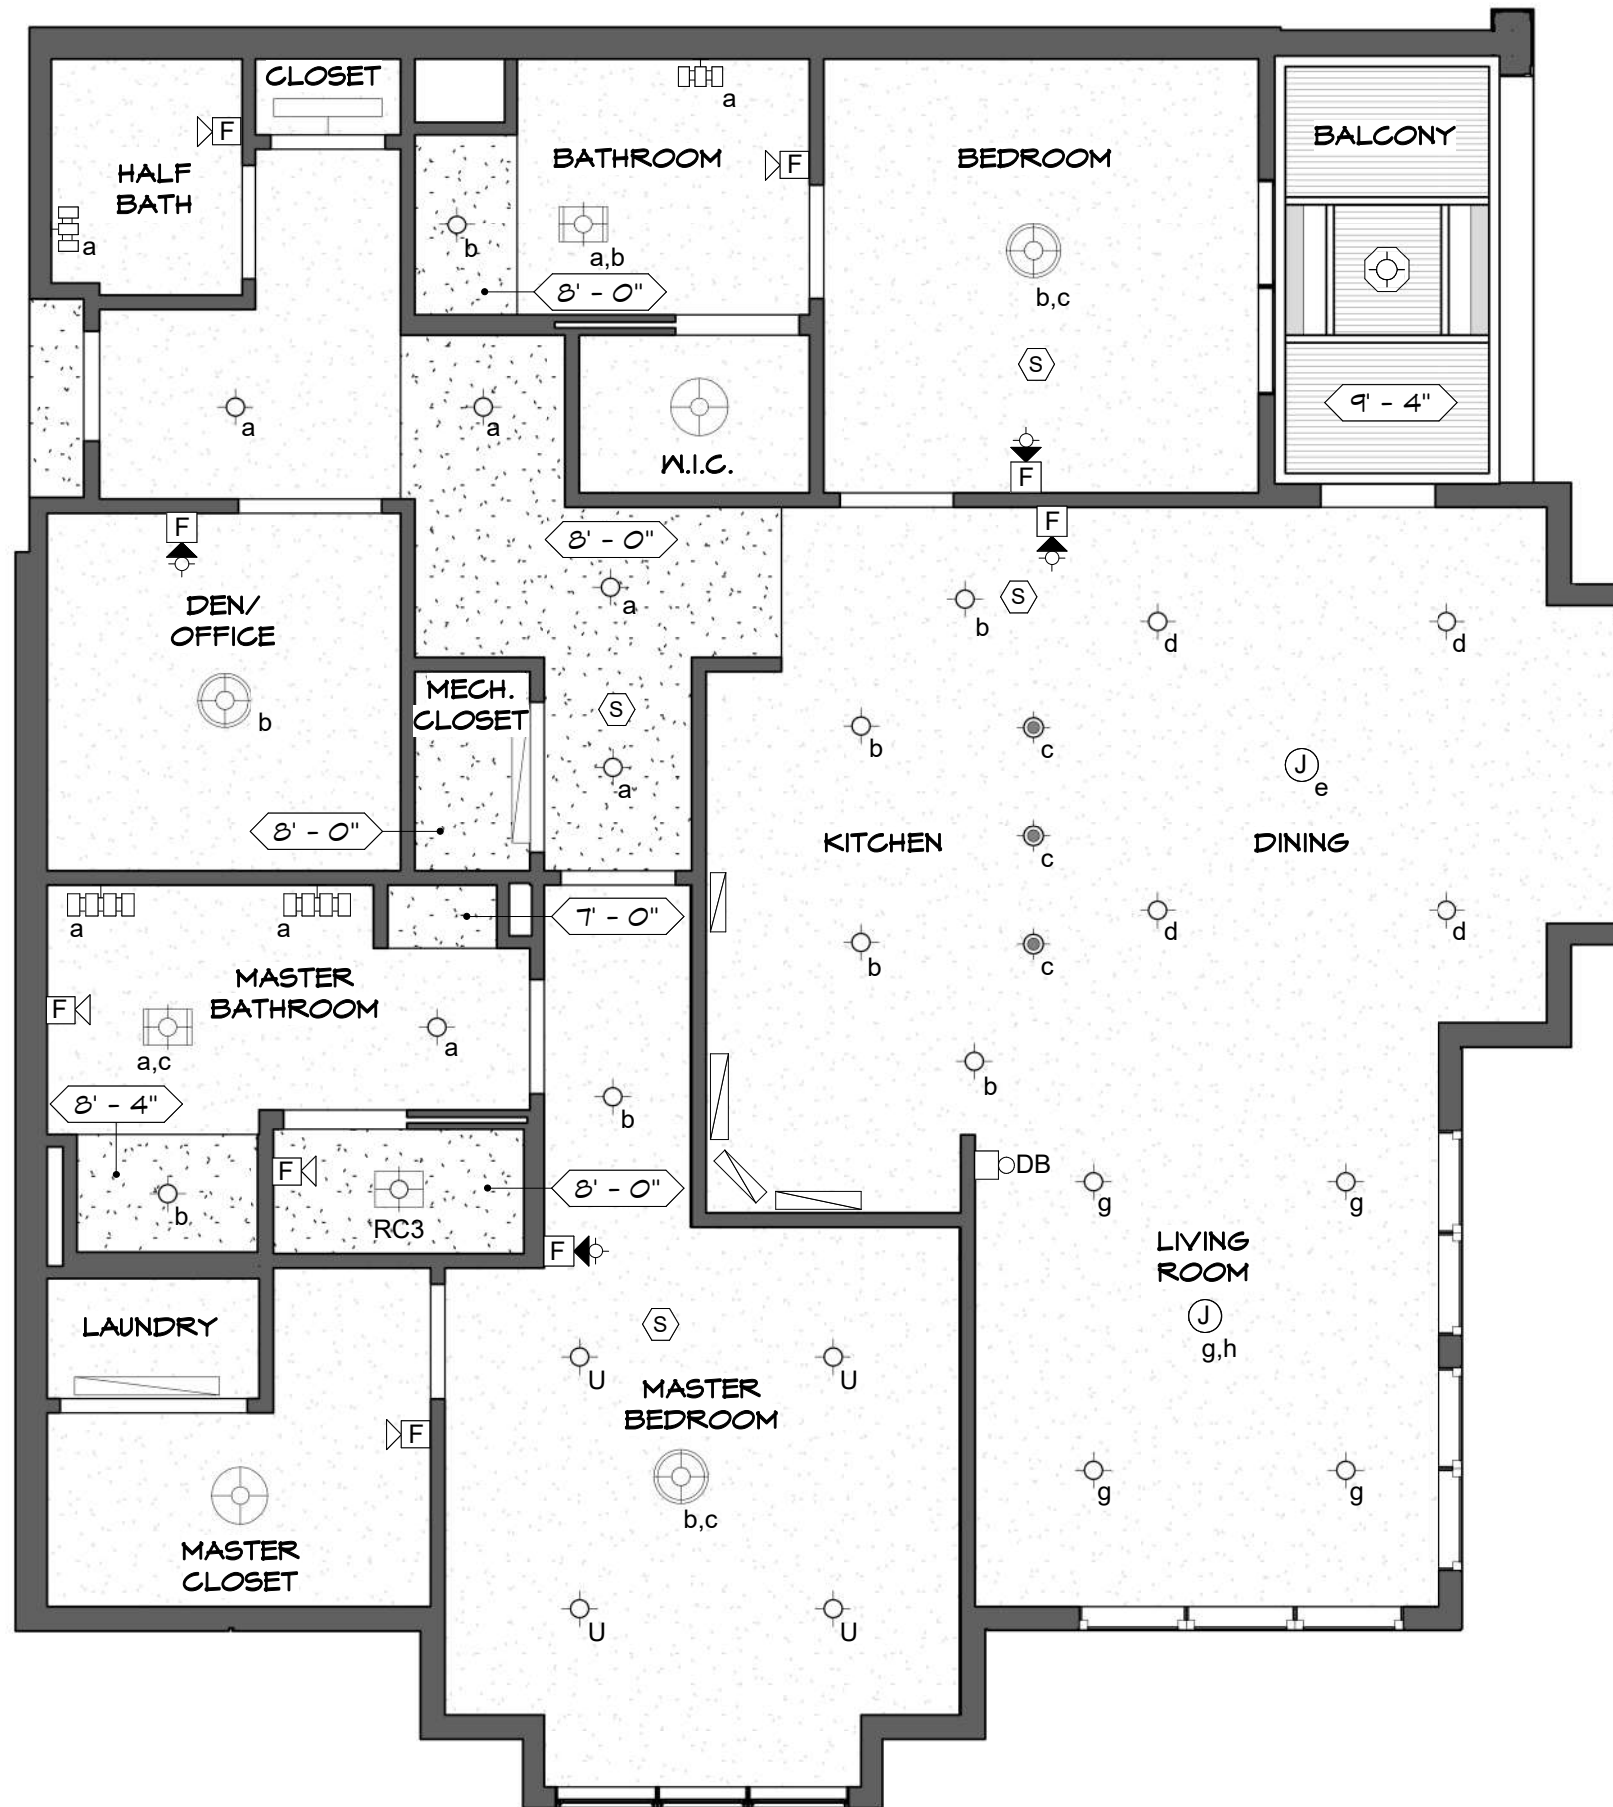











\*FLOOR PLAN  
SUBJECT TO CHANGE

SHEET 1 OF 2

9'-5" CEILING HEIGHT UNLESS NOTED OTHERWISE

 


### KEY LEGEND

-  JUNCTION BOX
-  SMOKE DETECTOR
-  4" DIAM. SHOWER LIGHT FIXTURE
-  6" DIAM. SURFACE MOUNTED LIGHT FIXTURE
-  6.5" DIAM. PENDANT LIGHT FIXTURE
-  18" DIAM. PENDANT LIGHT FIXTURE
-  19" DIAM. PENDANT LIGHT FIXTURE
-  COMBINATION LIGHT/HEATER/FAN
-  COMBINATION LIGHT/FAN
-  VANITY LIGHT BAR (3)
-  VANITY LIGHT BAR (4)
-  UNDERCABINET LIGHT FIXTURE
-  36" TROFFER LIGHT FIXTURE
-  48" TROFFER LIGHT FIXTURE
-  BALCONY LIGHT FIXTURE
-  UPGRADE - 6" DIAM. SURFACE MOUNTED LIGHT FIXTURE
-  FIRE ALARM AUDIO/VISUAL DEVICES
-  FIRE ALARM AUDIO DEVICE

## WOLFE II - UNIT 438 REFLECTED CEILING PLAN

SCALE: 3/16"=1'-0"



  
**SEARSTONE**  
RETIREMENT COMMUNITY

APPROVED: DATE:	WOLFE II
*FLOOR PLAN SUBJECT TO CHANGE	SHEET 2 OF 2