 

















 



 


**KEY LEGEND**

-  DUPLEX RECEPTACLE
-  DUPLEX RECEPTACLE TOP HALF SWITCHED
-  GF DUPLEX RECEPTACLE GROUND FAULT
-  FLOOR DUPLEX RECEPTACLE
-  R RANGE RECEPTACLE
-  M MICROWAVE RECEPTACLE
-  W WASHER RECEPTACLE
-  D DRYER RECEPTACLE
-  \* DUPLEX RECEPTACLE ABOVE COUNTER
-  J JUNCTION BOX
-  TD TELEPHONE-DATA OUTLET
-  TV TELEVISION-DATA OUTLET
-  T1 TELEPHONE OUTLET
-  DB DOOR BELL-INTERIOR
-  ● DB DOOR BELL
-  — RECESSED LOW VOLTAGE PANEL
-  — RECESSED ELECTRICAL PANEL
-  S WALL SWITCH
-  S<sub>3</sub> THREE-WAY SWITCH
-  S<sub>3D</sub> THREE-WAY DIMMER SWITCH
-  CPT. CARPET
-  LVT. LUXURY VINYL TILE

**McFADDEN - UNIT 447 | FLOOR PLAN**

SCALE: 3/16"=1'-0"



**SEARSTONE**  
RETIREMENT COMMUNITY


APPROVED:  
DATE:

McFADDEN

\*FLOOR PLAN  
SUBJECT TO CHANGE

SHEET 1 OF 2

9'-5" CEILING HEIGHT UNLESS NOTED OTHERWISE


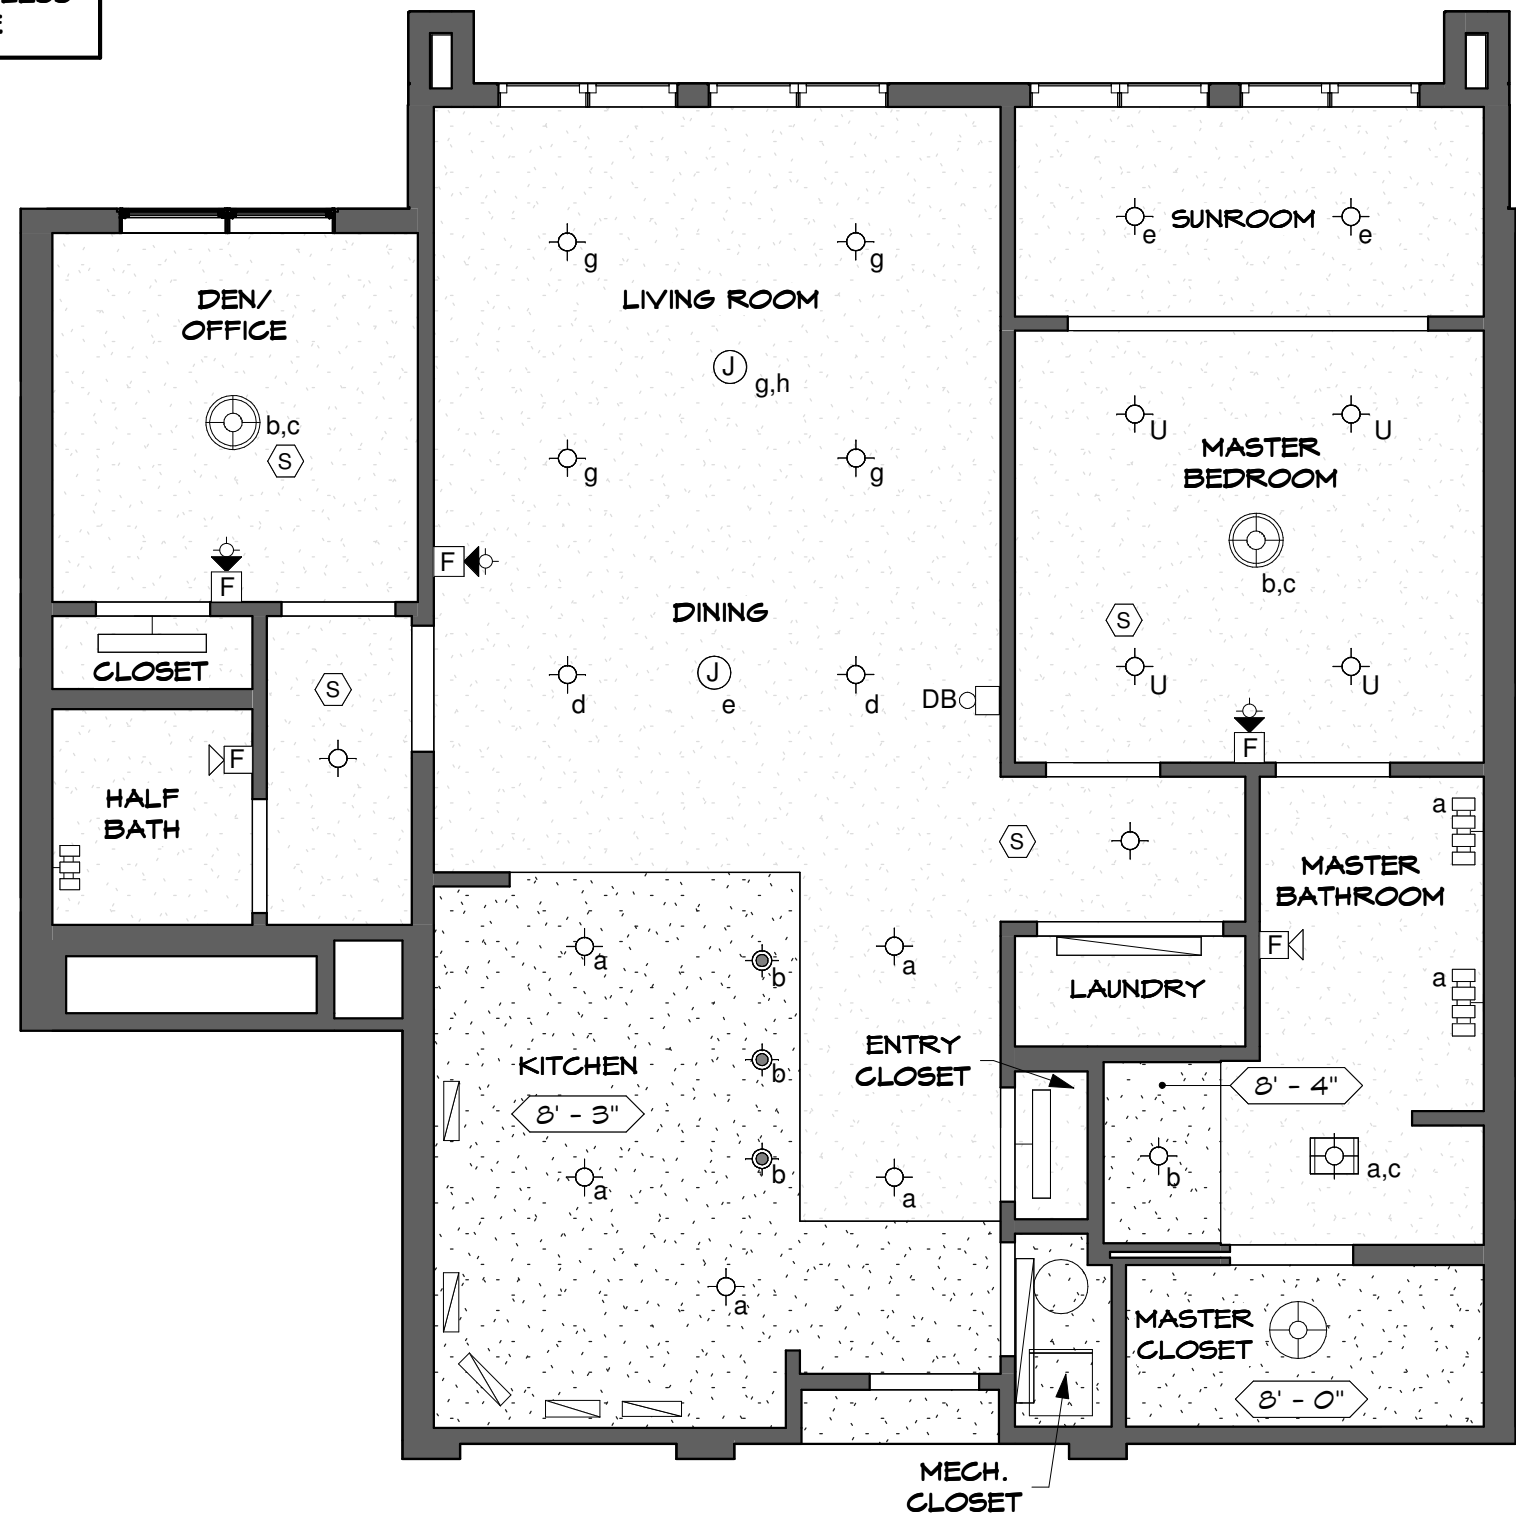


**KEY LEGEND**

- JUNCTION BOX
- SMOKE DETECTOR
- 4" DIAM. SHOWER LIGHT FIXTURE
- 6" DIAM. SURFACE MOUNTED LIGHT FIXTURE
- 6.5" DIAM. PENDANT LIGHT FIXTURE
- 18" DIAM. PENDANT LIGHT FIXTURE
- 19" DIAM. PENDANT LIGHT FIXTURE
- COMBINATION LIGHT/HEATER/FAN
- COMBINATION LIGHT/FAN
- VANITY LIGHT BAR (3)
- VANITY LIGHT BAR (4)
- UNDERCABINET LIGHT FIXTURE
- 36" TROFFER LIGHT FIXTURE
- 48" TROFFER LIGHT FIXTURE
- BALCONY LIGHT FIXTURE
- UPGRADE - 6" DIAM. SURFACE MOUNTED LIGHT FIXTURE
- FIRE ALARM AUDIO/VISUAL DEVICES
- FIRE ALARM AUDIO DEVICE

**McFADDEN - UNIT 447 REFLECTED CEILING PLAN**

 SCALE: 3/16"=1'-0"

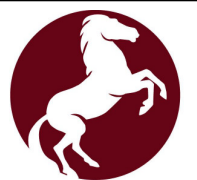

**SEARSTONE**  
RETIREMENT COMMUNITY

APPROVED:  
DATE:  
\*FLOOR PLAN  
SUBJECT TO CHANGE

McFADDEN

SHEET 2 OF 2