













 
 









**KEY LEGEND**

-  DUPLEX RECEPTACLE
-  DUPLEX RECEPTACLE TOP HALF SWITCHED
-  GF DUPLEX RECEPTACLE GROUND FAULT
-  FLOOR DUPLEX RECEPTACLE
-  R RANGE RECEPTACLE
-  M MICROWAVE RECEPTACLE
-  W WASHER RECEPTACLE
-  D DRYER RECEPTACLE
-  \* DUPLEX RECEPTACLE ABOVE COUNTER
-  J JUNCTION BOX
-  TD TELEPHONE-DATA OUTLET
-  TV TELEVISION-DATA OUTLET
-  T1 TELEPHONE OUTLET
-  DB DOOR BELL-INTERIOR
-  ● DB DOOR BELL
-  RECESSED LOW VOLTAGE PANEL
-  RECESSED ELECTRICAL PANEL
-  S WALL SWITCH
-  S<sub>3</sub> THREE-WAY SWITCH
-  S<sub>3D</sub> THREE-WAY DIMMER SWITCH
-  CPT. CARPET
-  LVT. LUXURY VINYL TILE

**FRANKLIN - UNIT 143 | FLOOR PLAN**

SCALE: 3/16"=1'-0"

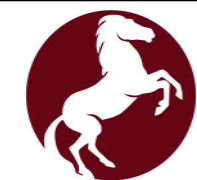

**SEARSTONE**  
RETIREMENT COMMUNITY


APPROVED:  
DATE:



 
 


 
 
 

 



 

 
 
FRANKLIN

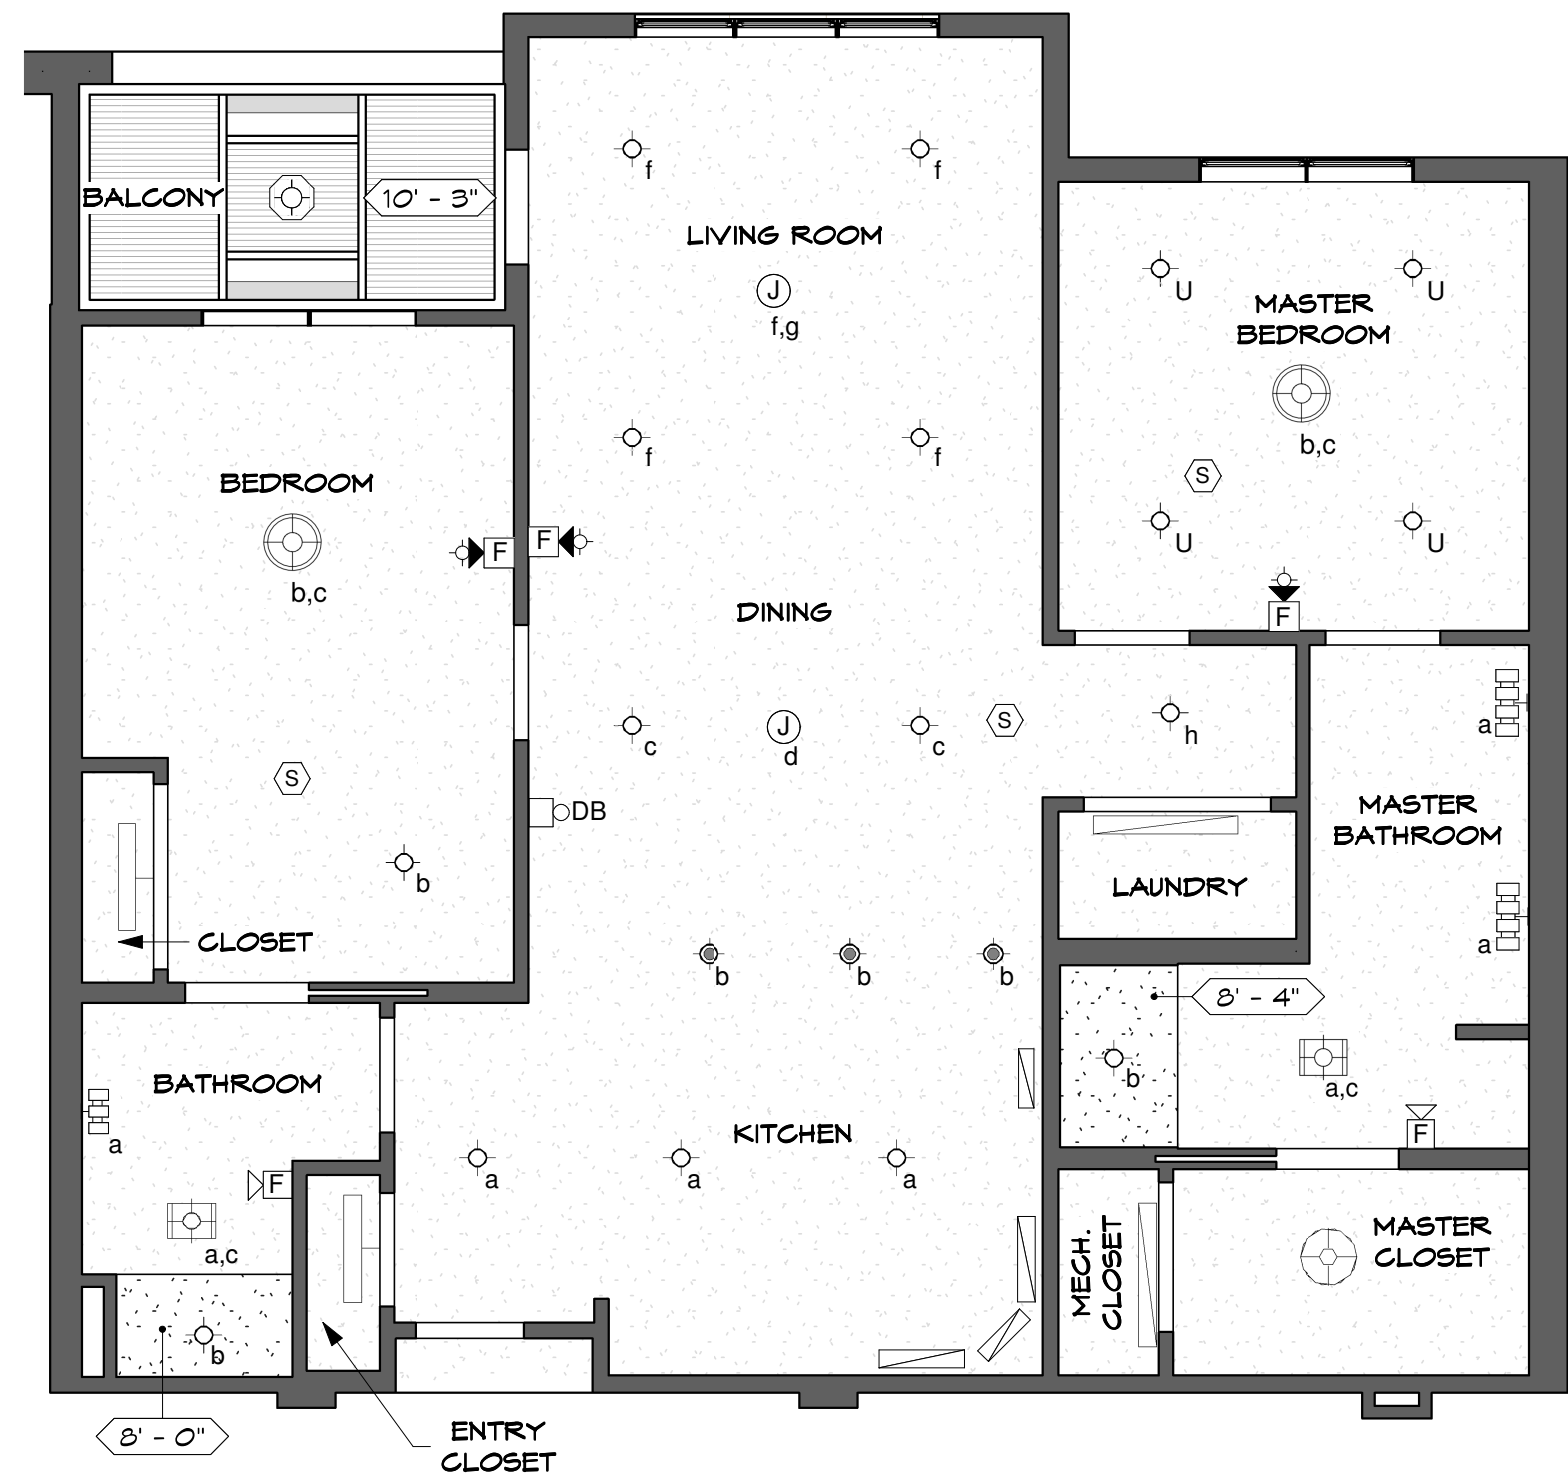\*FLOOR PLAN  
SUBJECT TO CHANGE

 
SHEET 1 OF 2

10'-0" CEILING HEIGHT  
UNLESS NOTED OTHERWISE



- KEY LEGEND**
-  JUNCTION BOX
  -  SMOKE DETECTOR
  -  4" DIAM. SHOWER LIGHT FIXTURE
  -  6" DIAM. SURFACE MOUNTED LIGHT FIXTURE
  -  6.5" DIAM. PENDANT LIGHT FIXTURE
  -  18" DIAM. PENDANT LIGHT FIXTURE
  -  19" DIAM. PENDANT LIGHT FIXTURE
  -  COMBINATION LIGHT/HEATER/FAN
  -  COMBINATION LIGHT/FAN
  -  VANITY LIGHT BAR (3)
  -  VANITY LIGHT BAR (4)
  -  UNDERCABINET LIGHT FIXTURE
  -  36" TROFFER LIGHT FIXTURE
  -  48" TROFFER LIGHT FIXTURE
  -  BALCONY LIGHT FIXTURE
  -  UPGRADE - 6" DIAM. SURFACE MOUNTED LIGHT FIXTURE
  -  FIRE ALARM AUDIO/VISUAL DEVICES
  -  FIRE ALARM AUDIO DEVICE

**FRANKLIN - UNIT 143** REFLECTED CEILING PLAN  
SCALE: 3/16"=1'-0"





**SEARSTONE**  
RETIREMENT COMMUNITY

APPROVED: DATE:	FRANKLIN
*FLOOR PLAN SUBJECT TO CHANGE	SHEET 2 OF 2