 


- KEY LEGEND**
- DUPLEX RECEPTACLE
 - DUPLEX RECEPTACLE TOP HALF SWITCHED
 - GF DUPLEX RECEPTACLE GROUND FAULT
 - FLOOR DUPLEX RECEPTACLE
 - R RANGE RECEPTACLE
 - M MICROWAVE RECEPTACLE
 - W WASHER RECEPTACLE
 - D DRYER RECEPTACLE
 - * DUPLEX RECEPTACLE ABOVE COUNTER
 - J JUNCTION BOX
 - TD TELEPHONE-DATA OUTLET
 - TV TELEVISION-DATA OUTLET
 - T1 TELEPHONE OUTLET
 - DB DOOR BELL-INTERIOR
 - DB DOOR BELL
 - RECESSED LOW VOLTAGE PANEL
 - RECESSED ELECTRICAL PANEL
 - S WALL SWITCH
 - S₃ THREE-WAY SWITCH
 - S_{3D} THREE-WAY DIMMER SWITCH
 - CPT. CARPET
 - LVT. LUXURY VINYL TILE


FRANKLIN - UNIT 145 FLOOR PLAN
SCALE: 3/16"=1'-0"




 
 

 



 


 


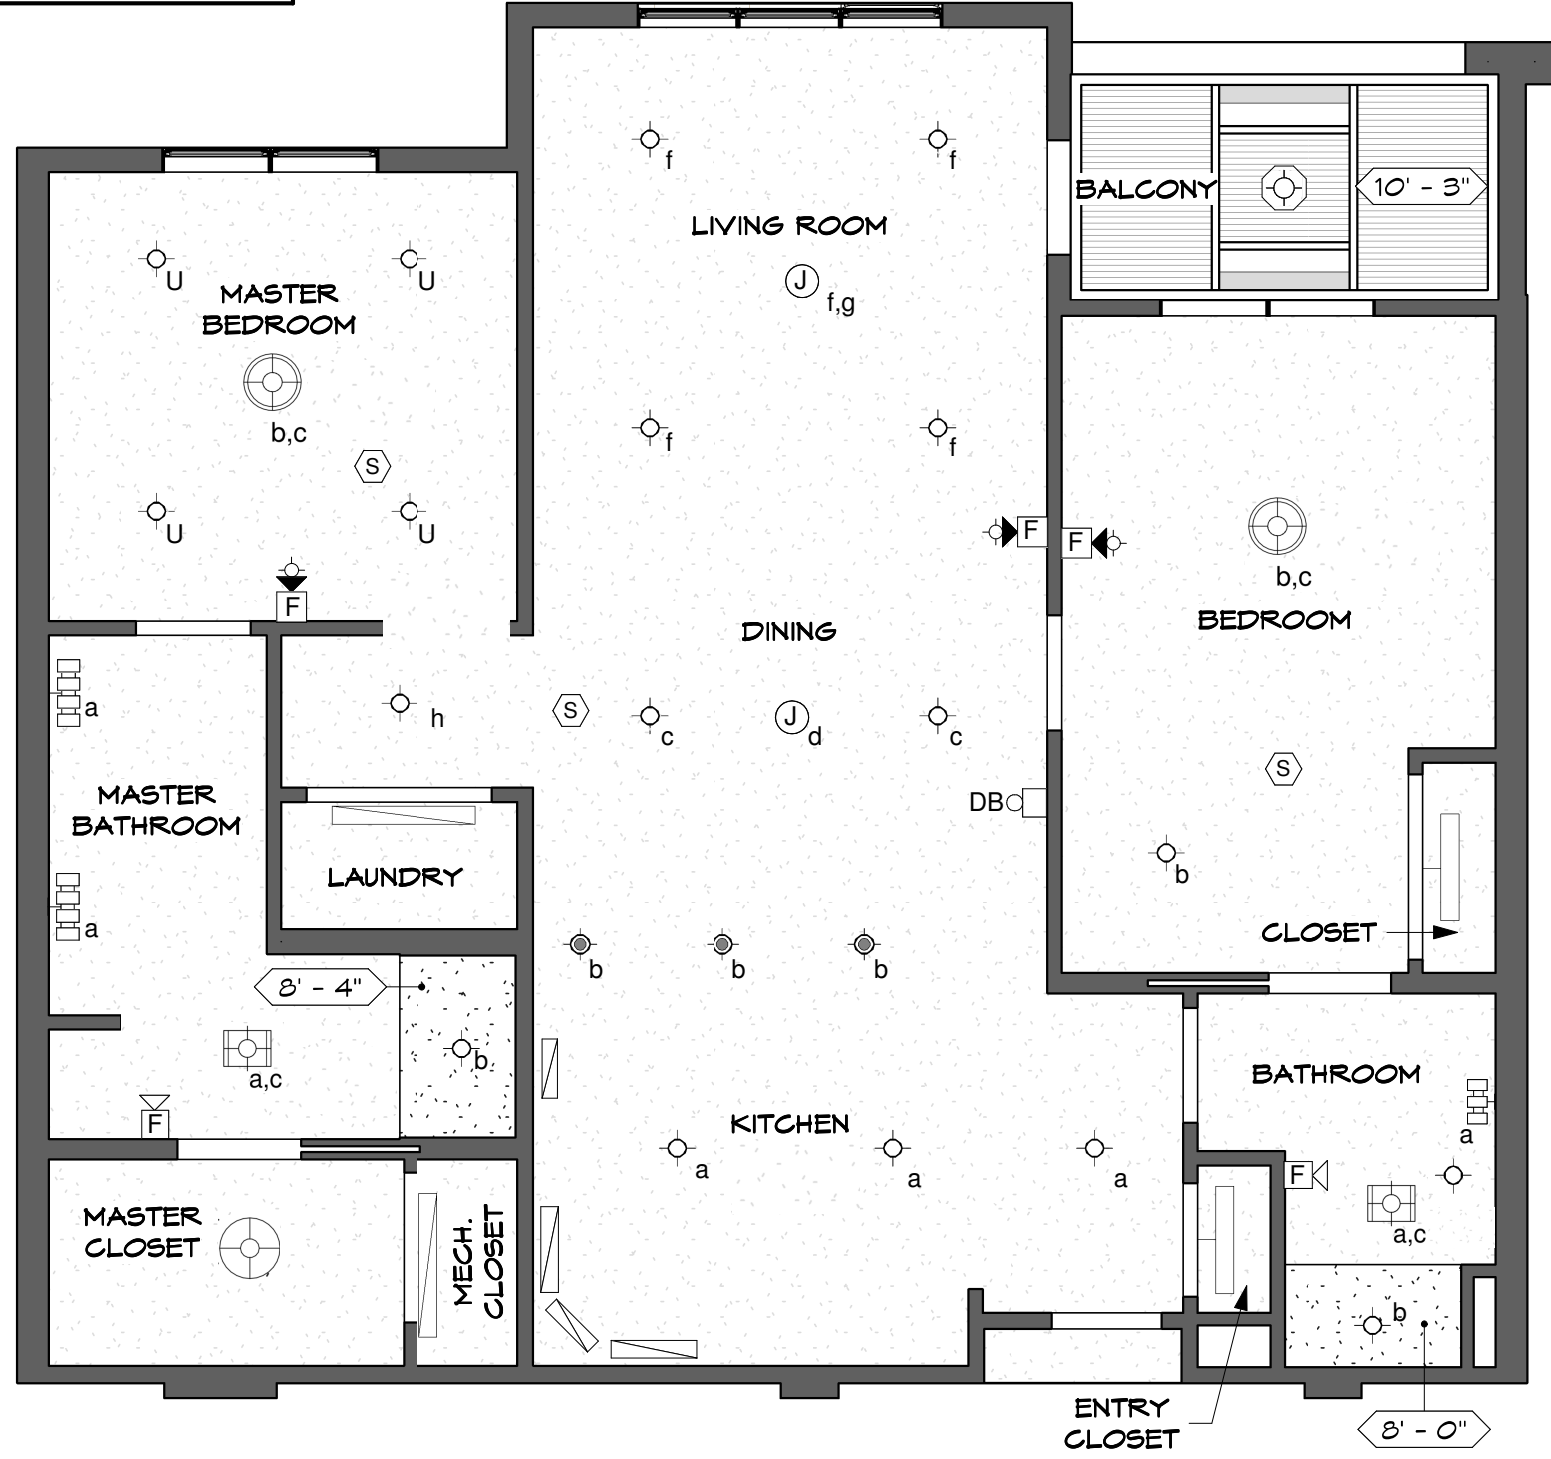



APPROVED: _____
DATE: _____
*FLOOR PLAN SUBJECT TO CHANGE

FRANKLIN
SHEET 1 OF 2

 
10'-0" CEILING HEIGHT
UNLESS NOTED OTHERWISE



KEY LEGEND

-  JUNCTION BOX
-  SMOKE DETECTOR
-  4" DIAM. SHOWER LIGHT FIXTURE
-  6" DIAM. SURFACE MOUNTED LIGHT FIXTURE
-  6.5" DIAM. PENDANT LIGHT FIXTURE
-  18" DIAM. PENDANT LIGHT FIXTURE
-  19" DIAM. PENDANT LIGHT FIXTURE
-  COMBINATION LIGHT/HEATER/FAN
-  COMBINATION LIGHT/FAN
-  VANITY LIGHT BAR (3)
-  VANITY LIGHT BAR (4)
-  UNDERCABINET LIGHT FIXTURE
-  36" TROFFER LIGHT FIXTURE
-  48" TROFFER LIGHT FIXTURE
-  BALCONY LIGHT FIXTURE
-  UPGRADE - 6" DIAM. SURFACE MOUNTED LIGHT FIXTURE
-  FIRE ALARM AUDIO/VISUAL DEVICES
-  FIRE ALARM AUDIO DEVICE

FRANKLIN - UNIT 145 REFLECTED CEILING PLAN
SCALE: 3/16"=1'-0"





SEARSTONE
RETIREMENT COMMUNITY

APPROVED:	FRANKLIN
DATE:	
*FLOOR PLAN SUBJECT TO CHANGE	SHEET 2 OF 2