













 
 





 
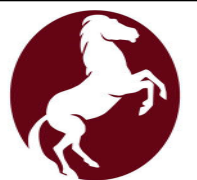


**KEY LEGEND**

-  DUPLEX RECEPTACLE
-  DUPLEX RECEPTACLE TOP HALF SWITCHED
-  GF DUPLEX RECEPTACLE GROUND FAULT
-  FLOOR DUPLEX RECEPTACLE
-  R RANGE RECEPTACLE
-  M MICROWAVE RECEPTACLE
-  W WASHER RECEPTACLE
-  D DRYER RECEPTACLE
-  \* DUPLEX RECEPTACLE ABOVE COUNTER
-  J JUNCTION BOX
-  TD TELEPHONE-DATA OUTLET
-  TV TELEVISION-DATA OUTLET
-  T1 TELEPHONE OUTLET
-  DB DOOR BELL-INTERIOR
-  ● DB DOOR BELL
-  RECESSED LOW VOLTAGE PANEL
-  RECESSED ELECTRICAL PANEL
-  S WALL SWITCH
-  S<sub>3</sub> THREE-WAY SWITCH
-  S<sub>3D</sub> THREE-WAY DIMMER SWITCH
-  CPT. CARPET
-  LVT. LUXURY VINYL TILE

**TIMBERLAKE II - UNIT 407 FLOOR PLAN**

SCALE: 3/16"=1'-0"




**SEARSTONE**  
RETIREMENT COMMUNITY

APPROVED:  
DATE:  
\*FLOOR PLAN  
SUBJECT TO CHANGE




 



 

 

 
 


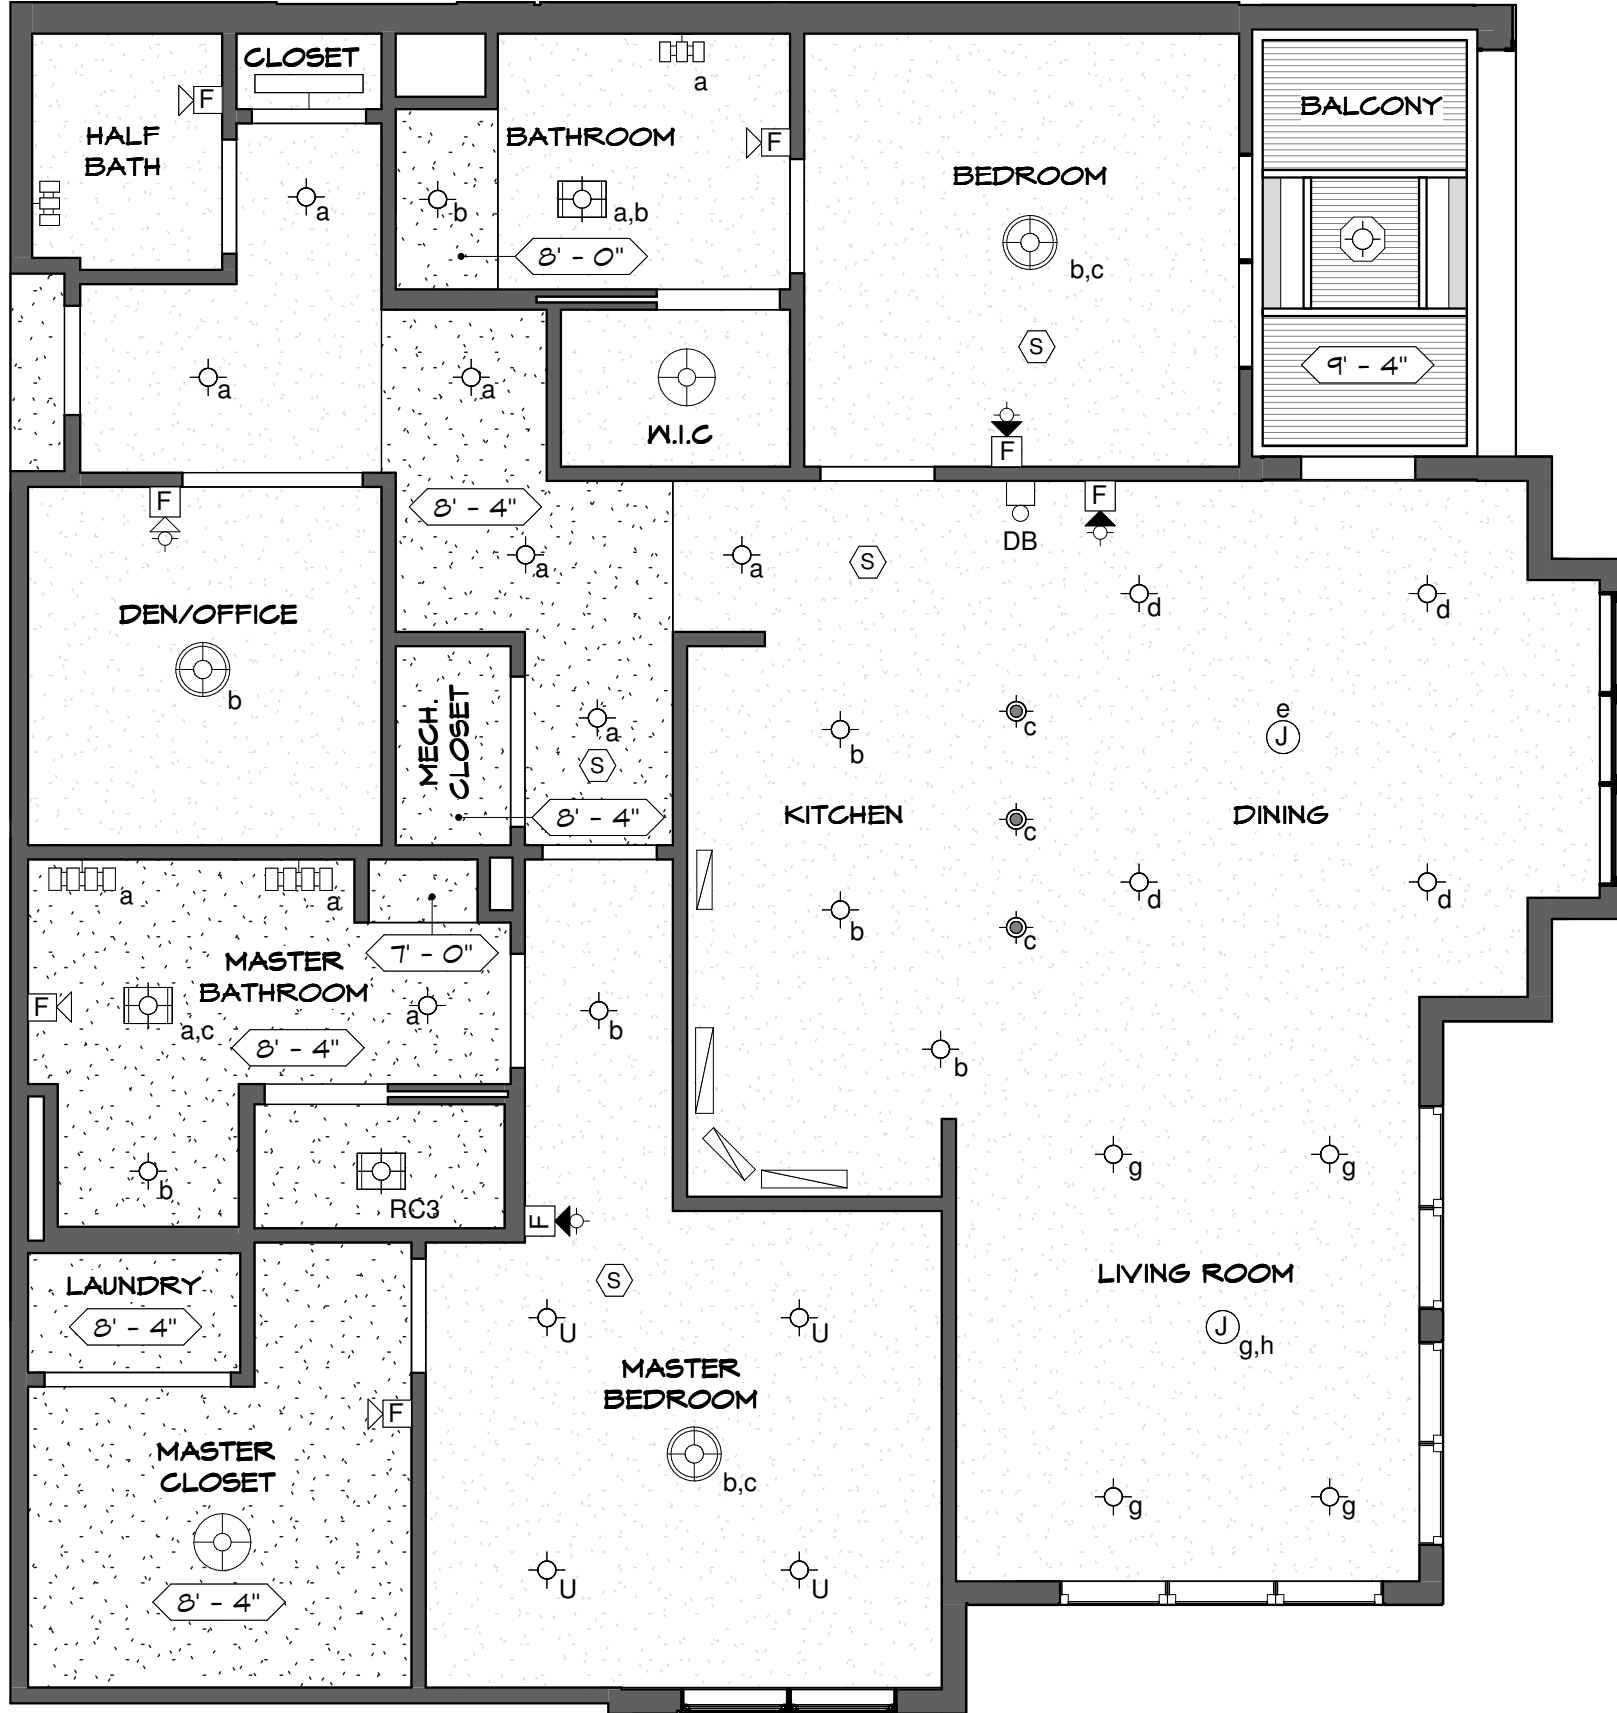


TIMBERLAKE II

SHEET 1 OF 2

9'-5" CEILING HEIGHT UNLESS NOTED OTHERWISE




**KEY LEGEND**

-  JUNCTION BOX
-  SMOKE DETECTOR
-  4" DIAM. SHOWER LIGHT FIXTURE
-  6" DIAM. SURFACE MOUNTED LIGHT FIXTURE
-  6.5" DIAM. PENDANT LIGHT FIXTURE
-  18" DIAM. PENDANT LIGHT FIXTURE
-  19" DIAM. PENDANT LIGHT FIXTURE
-  COMBINATION LIGHT/HEATER/FAN
-  COMBINATION LIGHT/FAN
-  VANITY LIGHT BAR (3)
-  VANITY LIGHT BAR (4)
-  UNDERCABINET LIGHT FIXTURE
-  36" TROFFER LIGHT FIXTURE
-  48" TROFFER LIGHT FIXTURE
-  BALCONY LIGHT FIXTURE
-  UPGRADE - 6" DIAM. SURFACE MOUNTED LIGHT FIXTURE
-  FIRE ALARM AUDIO/VISUAL DEVICES
-  FIRE ALARM AUDIO DEVICE

**TIMBERLAKE II - UNIT 407 REFLECTED CEILING PLAN**

SCALE: 3/16"=1'-0"

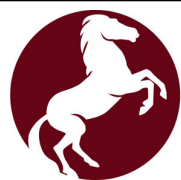

**SEARSTONE**  
RETIREMENT COMMUNITY

APPROVED:  
DATE:

TIMBERLAKE II

\*FLOOR PLAN  
SUBJECT TO CHANGE

SHEET 2 OF 2