













 
 









KEY LEGEND

-  DUPLEX RECEPTACLE
-  DUPLEX RECEPTACLE TOP HALF SWITCHED
-  GF DUPLEX RECEPTACLE GROUND FAULT
-  FLOOR DUPLEX RECEPTACLE
-  R RANGE RECEPTACLE
-  M MICROWAVE RECEPTACLE
-  W WASHER RECEPTACLE
-  D DRYER RECEPTACLE
-  * DUPLEX RECEPTACLE ABOVE COUNTER
-  J JUNCTION BOX
-  TD TELEPHONE-DATA OUTLET
-  TV TELEVISION-DATA OUTLET
-  T1 TELEPHONE OUTLET
-  DB DOOR BELL-INTERIOR
-  DB DOOR BELL
-  RECESSED LOW VOLTAGE PANEL
-  RECESSED ELECTRICAL PANEL
-  S WALL SWITCH
-  S₃ THREE-WAY SWITCH
-  S_{3D} THREE-WAY DIMMER SWITCH
-  CPT. CARPET
-  LVT. LUXURY VINYL TILE

BENNETT - UNIT 334 | FLOOR PLAN

SCALE: 3/16"=1'-0"

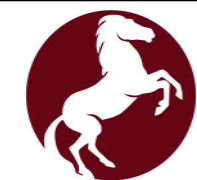

SEARSTONE
RETIREMENT COMMUNITY


APPROVED:
DATE:

BENNETT

*FLOOR PLAN
SUBJECT TO CHANGE

SHEET 1 OF 2

9'-6" CEILING HEIGHT UNLESS NOTED OTHERWISE

 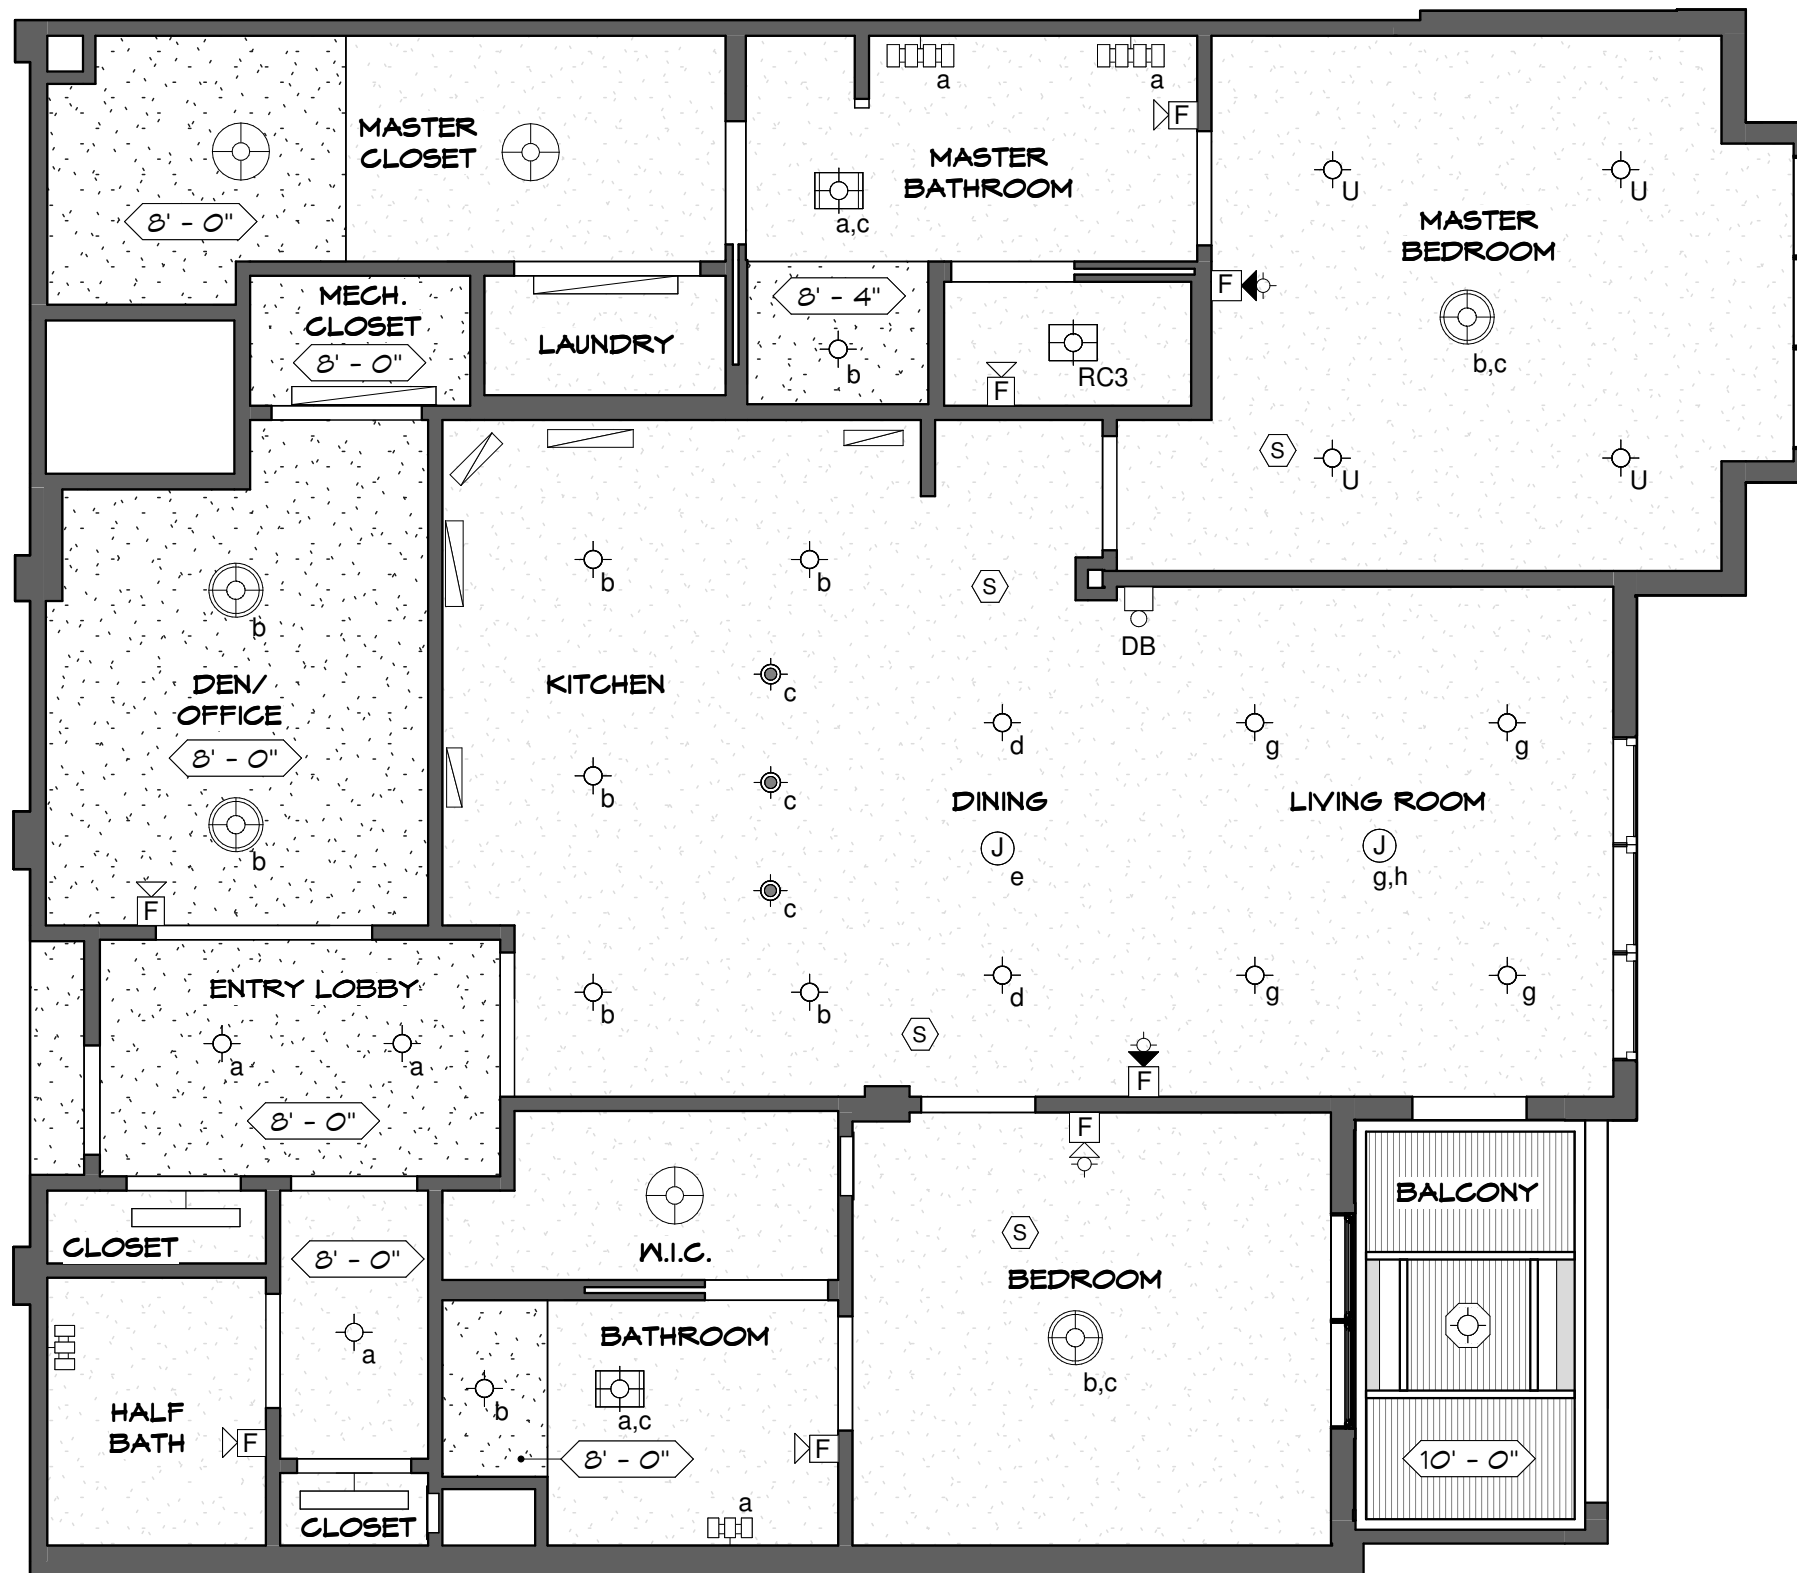


KEY LEGEND

- ⓐ JUNCTION BOX
- Ⓢ SMOKE DETECTOR
- Ⓤ 4" DIAM. SHOWER LIGHT FIXTURE
- Ⓦ 6" DIAM. SURFACE MOUNTED LIGHT FIXTURE
- Ⓡ 6.5" DIAM. PENDANT LIGHT FIXTURE
- Ⓢ 18" DIAM. PENDANT LIGHT FIXTURE
- Ⓢ 19" DIAM. PENDANT LIGHT FIXTURE
- Ⓦ COMBINATION LIGHT/HEATER/FAN
- Ⓦ COMBINATION LIGHT/FAN
- Ⓦ VANITY LIGHT BAR (3)
- Ⓦ VANITY LIGHT BAR (4)
- ▬ UNDERCABINET LIGHT FIXTURE
- ▬ 36" TROFFER LIGHT FIXTURE
- ▬ 48" TROFFER LIGHT FIXTURE
- Ⓢ BALCONY LIGHT FIXTURE
- Ⓤ UPGRADE - 6" DIAM. SURFACE MOUNTED LIGHT FIXTURE
- Ⓢ F FIRE ALARM AUDIO/VISUAL DEVICES
- Ⓢ F FIRE ALARM AUDIO DEVICE

BENNETT - UNIT 334 REFLECTED CEILING PLAN

SCALE: 3/16"=1'-0"




APPROVED:
DATE:

BENNETT

*FLOOR PLAN
SUBJECT TO CHANGE

SHEET 2 OF 2

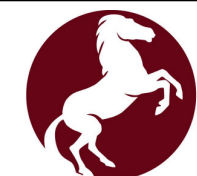

SEARSTONE
RETIREMENT COMMUNITY