













 



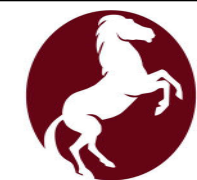


KEY LEGEND

-  JUNCTION BOX
-  SMOKE DETECTOR
-  4" DIAM. SHOWER LIGHT FIXTURE
-  6" DIAM. SURFACE MOUNTED LIGHT FIXTURE
-  6.5" DIAM. PENDANT LIGHT FIXTURE
-  18" DIAM. PENDANT LIGHT FIXTURE
-  19" DIAM. PENDANT LIGHT FIXTURE
-  COMBINATION LIGHT/HEATER/FAN
-  COMBINATION LIGHT/FAN
-  VANITY LIGHT BAR (3)
-  VANITY LIGHT BAR (4)
-  UNDERCABINET LIGHT FIXTURE
-  36" TROFFER LIGHT FIXTURE
-  48" TROFFER LIGHT FIXTURE
-  BALCONY LIGHT FIXTURE
-  UPGRADE - 6" DIAM. SURFACE MOUNTED LIGHT FIXTURE
-  FIRE ALARM AUDIO/VISUAL DEVICES
-  FIRE ALARM AUDIO DEVICE

COLTRANE II - UNIT 336 | FLOOR PLAN

SCALE: 3/16"=1'-0"



SEARSTONE
RETIREMENT COMMUNITY


APPROVED:
DATE:

COLTRANE II

*FLOOR PLAN
SUBJECT TO CHANGE

SHEET 1 OF 2

9'-6" CEILING HEIGHT UNLESS NOTED OTHERWISE

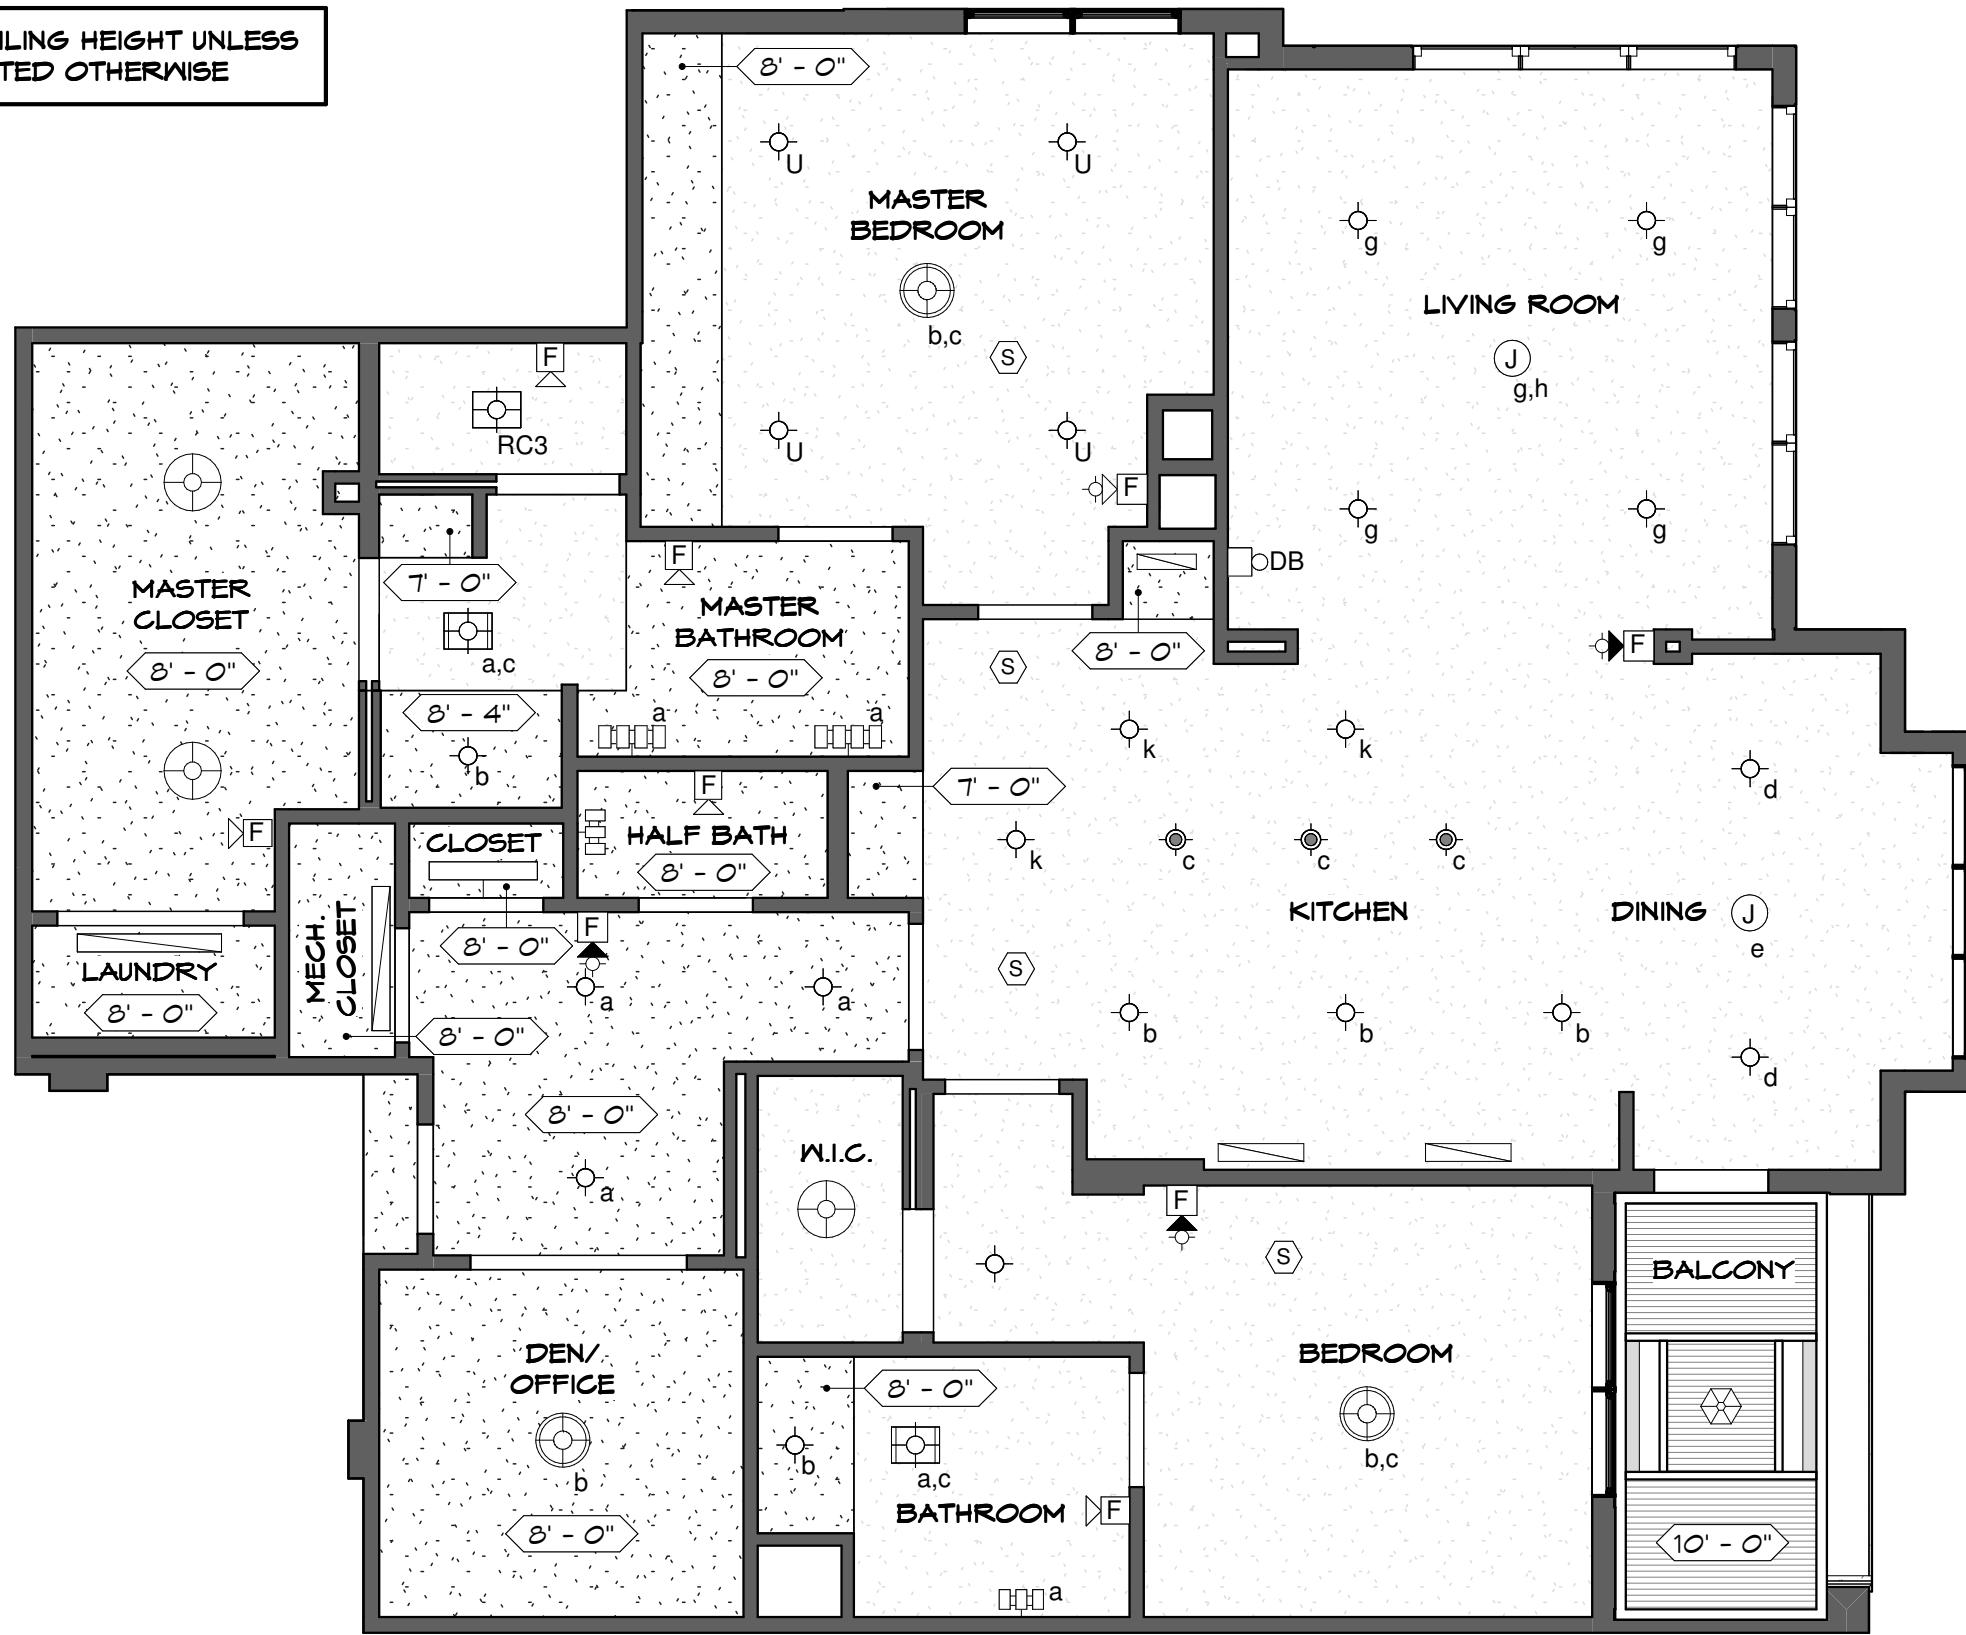


KEY LEGEND

- JUNCTION BOX
- SMOKE DETECTOR
- 4" DIAM. SHOWER LIGHT FIXTURE
- 6" DIAM. SURFACE MOUNTED LIGHT FIXTURE
- 6.5" DIAM. PENDANT LIGHT FIXTURE
- 18" DIAM. PENDANT LIGHT FIXTURE
- 19" DIAM. PENDANT LIGHT FIXTURE
- COMBINATION LIGHT/HEATER/FAN
- COMBINATION LIGHT/FAN
- VANITY LIGHT BAR (3)
- VANITY LIGHT BAR (4)
- UNDERCABINET LIGHT FIXTURE
- 36" TROFFER LIGHT FIXTURE
- 48" TROFFER LIGHT FIXTURE
- BALCONY LIGHT FIXTURE
- UPGRADE - 6" DIAM. SURFACE MOUNTED LIGHT FIXTURE
- FIRE ALARM AUDIO/VISUAL DEVICES
- FIRE ALARM AUDIO DEVICE

COLTRANE II - UNIT 336

REFLECTED CEILING PLAN

SCALE: 3/16"=1'-0"

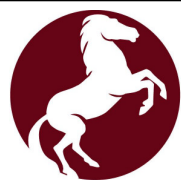

SEARSTONE
RETIREMENT COMMUNITY

APPROVED:
DATE:

COLTRANE II

*FLOOR PLAN
SUBJECT TO CHANGE

SHEET 2 OF 2