













 
 







KEY LEGEND

-  JUNCTION BOX
-  SMOKE DETECTOR
-  4" DIAM. SHOWER LIGHT FIXTURE
-  6" DIAM. SURFACE MOUNTED LIGHT FIXTURE
-  6.5" DIAM. PENDANT LIGHT FIXTURE
-  18" DIAM. PENDANT LIGHT FIXTURE
-  19" DIAM. PENDANT LIGHT FIXTURE
-  COMBINATION LIGHT/HEATER/FAN
-  COMBINATION LIGHT/FAN
-  VANITY LIGHT BAR (3)
-  VANITY LIGHT BAR (4)
-  UNDERCABINET LIGHT FIXTURE
-  36" TROFFER LIGHT FIXTURE
-  48" TROFFER LIGHT FIXTURE
-  BALCONY LIGHT FIXTURE
-  UPGRADE - 6" DIAM. SURFACE MOUNTED LIGHT FIXTURE
-  FIRE ALARM AUDIO/VISUAL DEVICES
-  FIRE ALARM AUDIO DEVICE



COLTRANE II - UNIT 436 | FLOOR PLAN

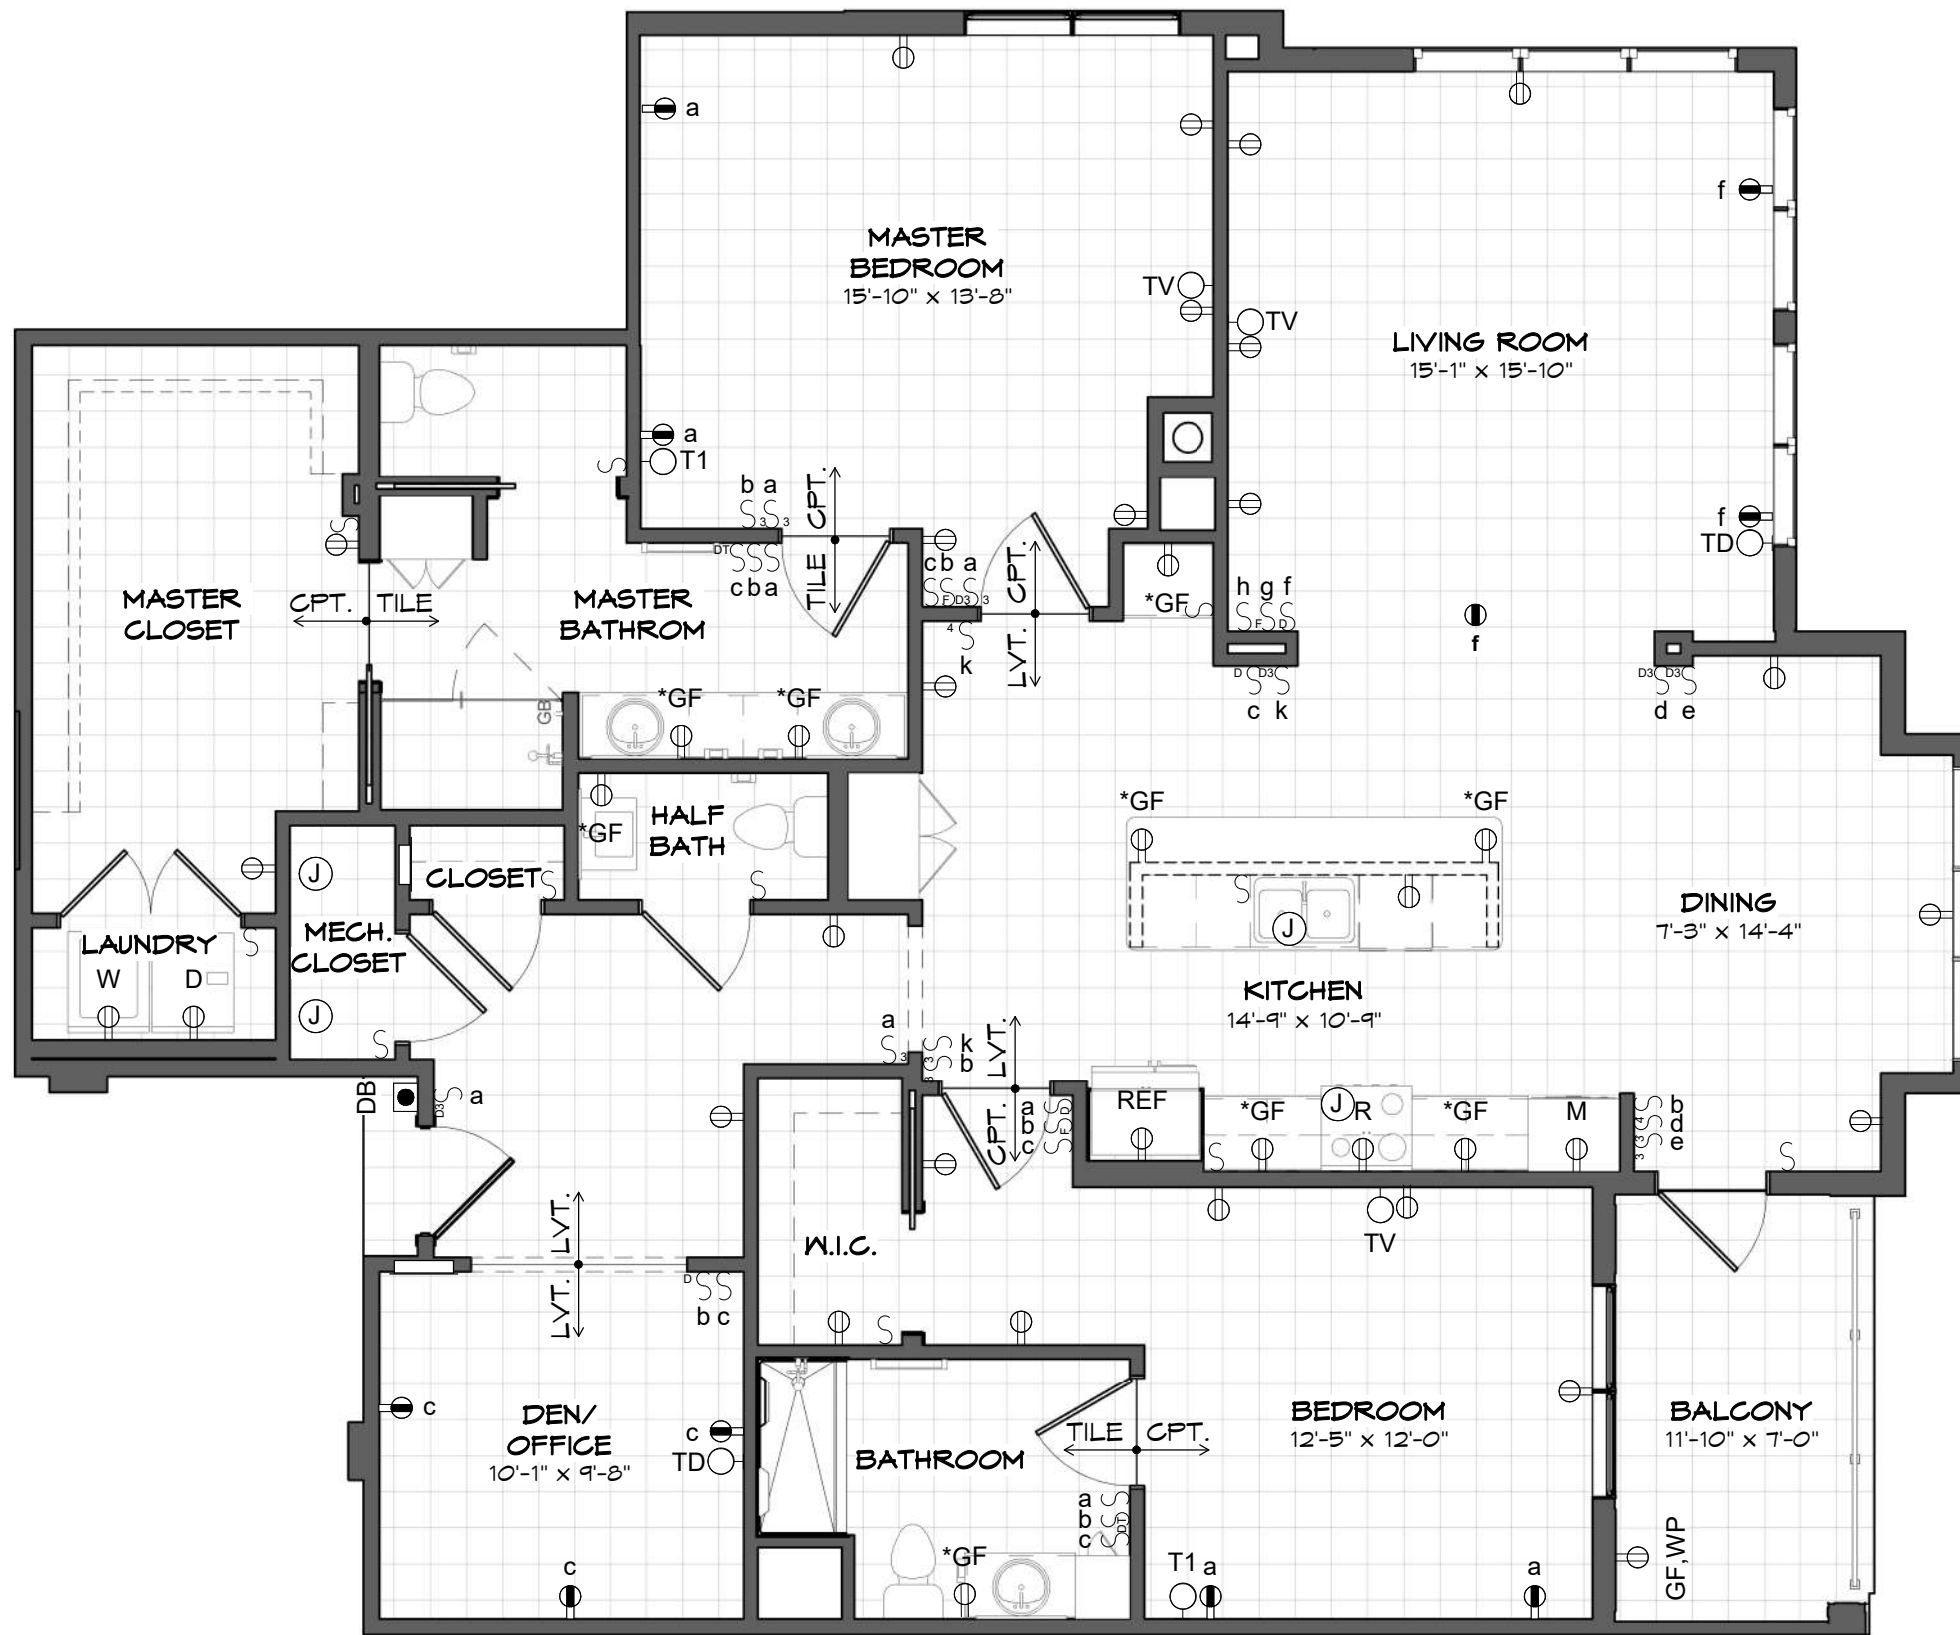SCALE: 3/16"=1'-0"

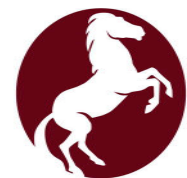 

SEARSTONE
RETIREMENT COMMUNITY


APPROVED:
DATE:

COLTRANE II

*FLOOR PLAN
SUBJECT TO CHANGE

SHEET 1 OF 2

9'-5" CEILING HEIGHT UNLESS NOTED OTHERWISE

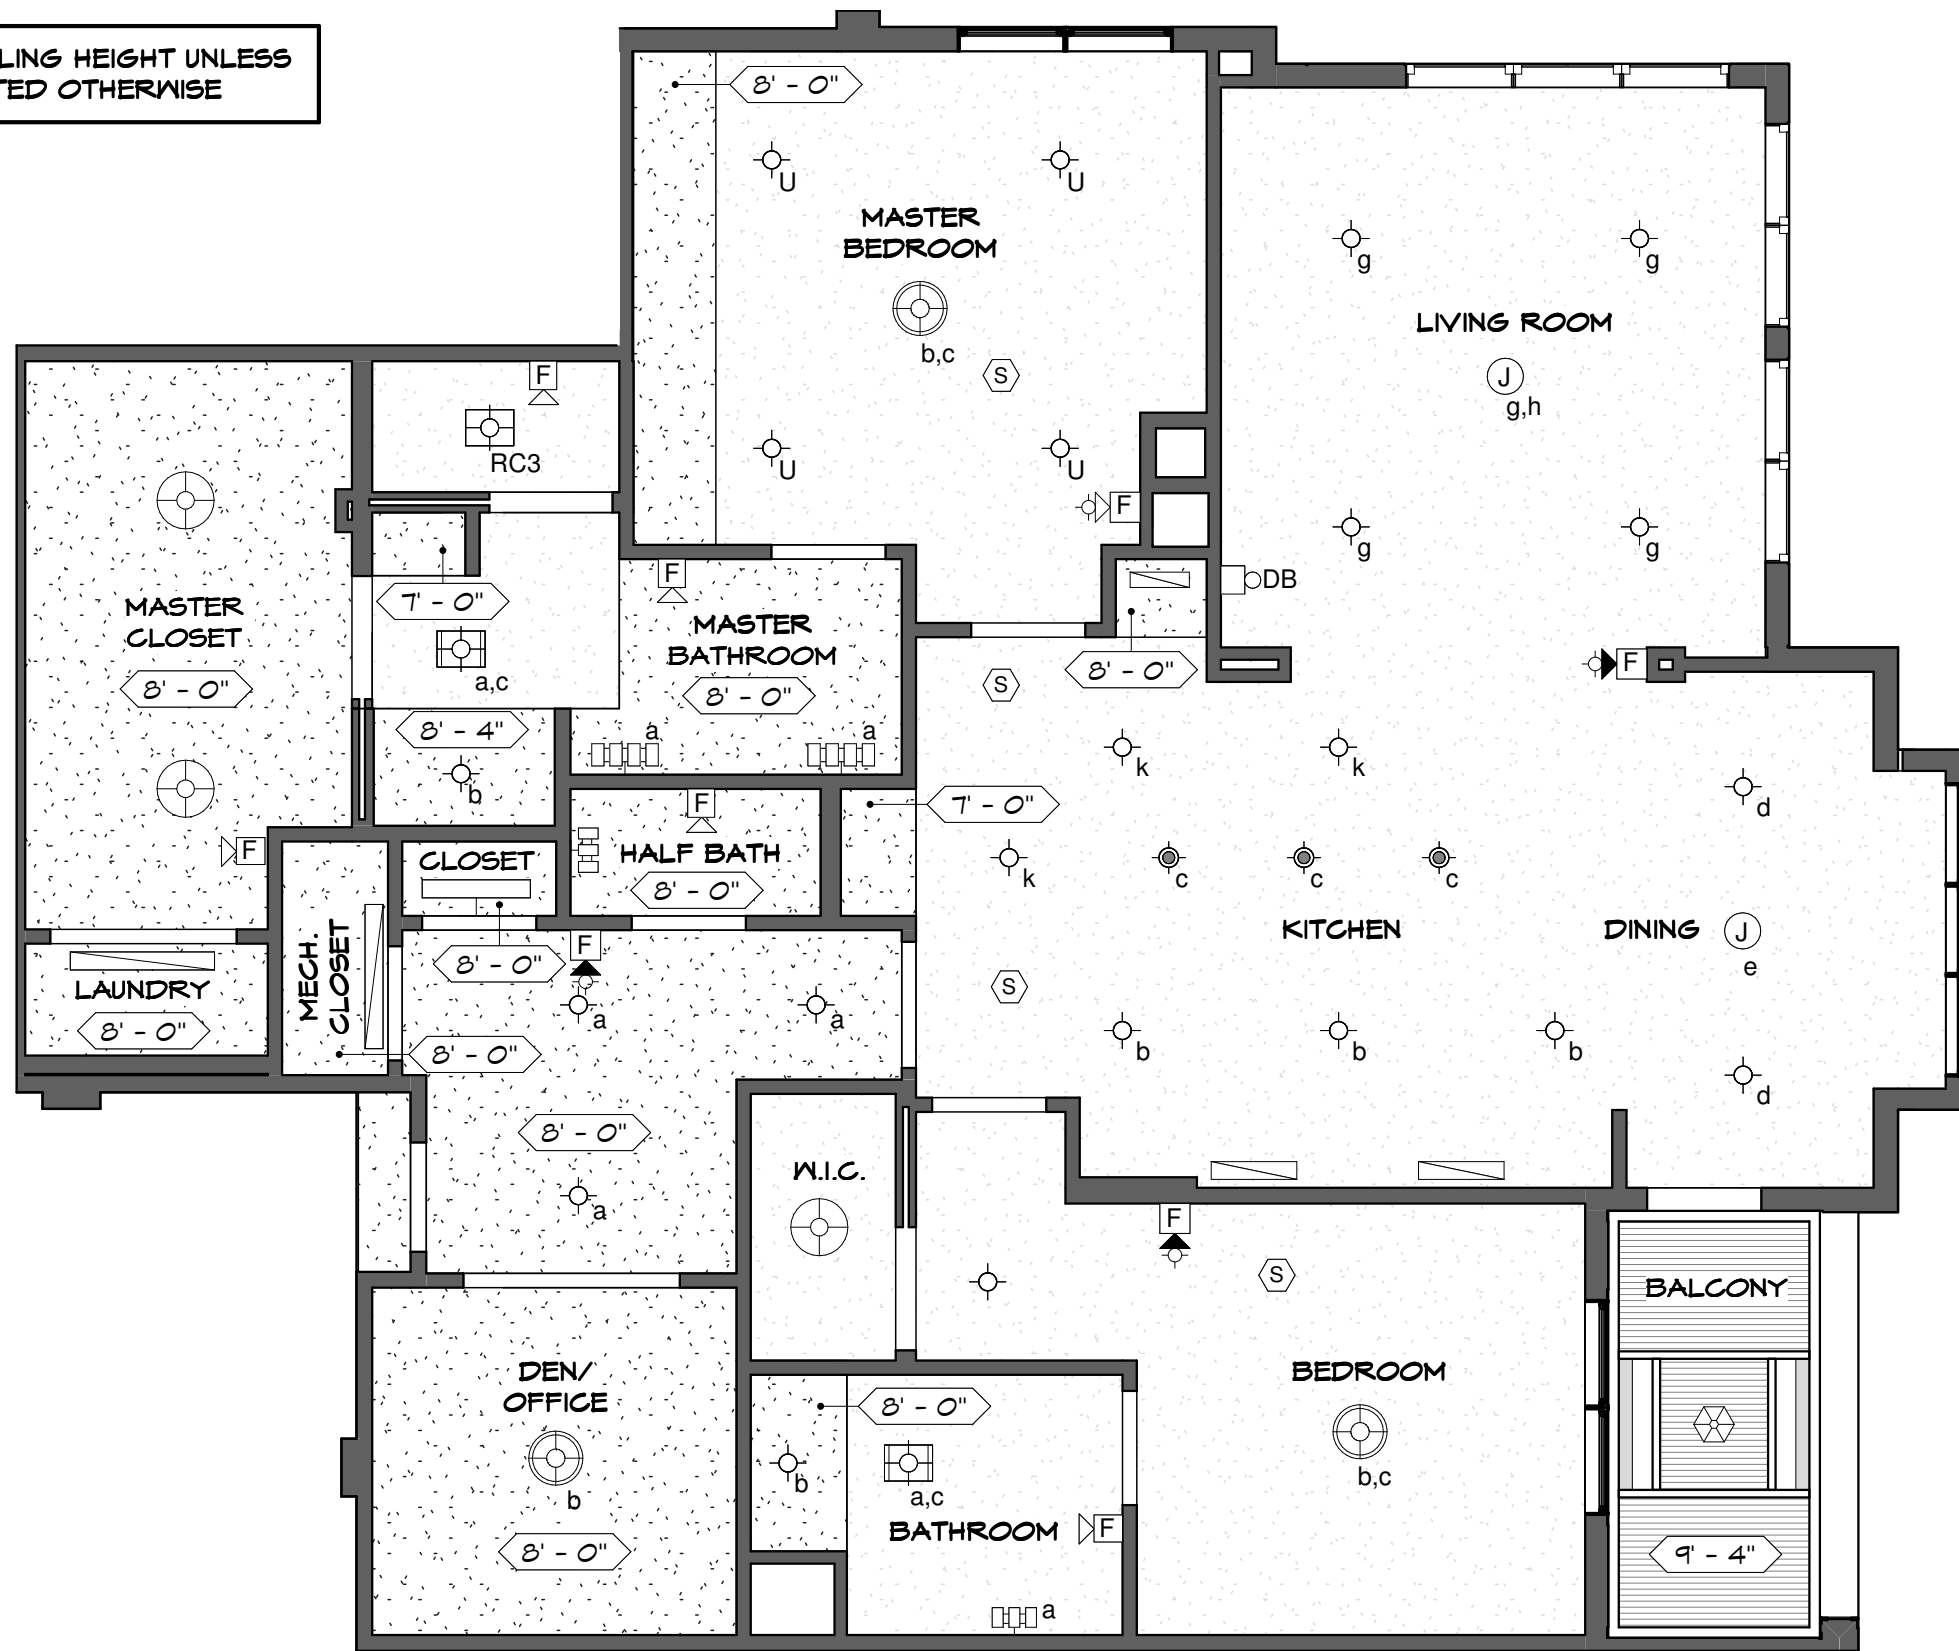


KEY LEGEND

- ⓐ JUNCTION BOX
- Ⓢ SMOKE DETECTOR
- ⊙ 4" DIAM. SHOWER LIGHT FIXTURE
- ⊙ 6" DIAM. SURFACE MOUNTED LIGHT FIXTURE
- ⊙ 6.5" DIAM. PENDANT LIGHT FIXTURE
- ⊙ 18" DIAM. PENDANT LIGHT FIXTURE
- ⊙ 19" DIAM. PENDANT LIGHT FIXTURE
- ⊙ COMBINATION LIGHT/HEATER/FAN
- ⊙ COMBINATION LIGHT/FAN
- ▭ VANITY LIGHT BAR (3)
- ▭ VANITY LIGHT BAR (4)
- ▭ UNDERCABINET LIGHT FIXTURE
- ▭ 36" TROFFER LIGHT FIXTURE
- ▭ 48" TROFFER LIGHT FIXTURE
- ⊙ BALCONY LIGHT FIXTURE
- ⊙ UPGRADE - 6" DIAM. SURFACE MOUNTED LIGHT FIXTURE
- Ⓢ FIRE ALARM AUDIO/VISUAL DEVICES
- Ⓢ FIRE ALARM AUDIO DEVICE

COLTRANE II - UNIT 436

REFLECTED CEILING PLAN

 SCALE: 3/16"=1'-0"



SEARSTONE
RETIREMENT COMMUNITY

APPROVED:
DATE:

COLTRANE II

*FLOOR PLAN
SUBJECT TO CHANGE

SHEET 2 OF 2