

KEY LEGEND

- DUPLEX RECEPTACLE
- DUPLEX RECEPTACLE TOP HALF SWITCHED
- GF DUPLEX RECEPTACLE GROUND FAULT
- FLOOR DUPLEX RECEPTACLE
- R RANGE RECEPTACLE
- M MICROWAVE RECEPTACLE
- W WASHER RECEPTACLE
- D DRYER RECEPTACLE
- * DUPLEX RECEPTACLE ABOVE COUNTER
- J JUNCTION BOX
- TD TELEPHONE-DATA OUTLET
- TV TELEVISION-DATA OUTLET
- T1 TELEPHONE OUTLET
- DB DOOR BELL-INTERIOR
- DB DOOR BELL
- RECESSED LOW VOLTAGE PANEL
- RECESSED ELECTRICAL PANEL
- S WALL SWITCH
- S₃ THREE-WAY SWITCH
- S_{3D} THREE-WAY DIMMER SWITCH
- CPT. CARPET
- LVT. LUXURY VINYL TILE

MADISON - UNIT 302 | FLOOR PLAN

SCALE: 3/16"=1'-0"



SEARSTONE
RETIREMENT COMMUNITY


APPROVED:
DATE:

MADISON

*FLOOR PLAN
SUBJECT TO CHANGE

SHEET 1 OF 2

9'-6" CEILING HEIGHT UNLESS NOTED OTHERWISE

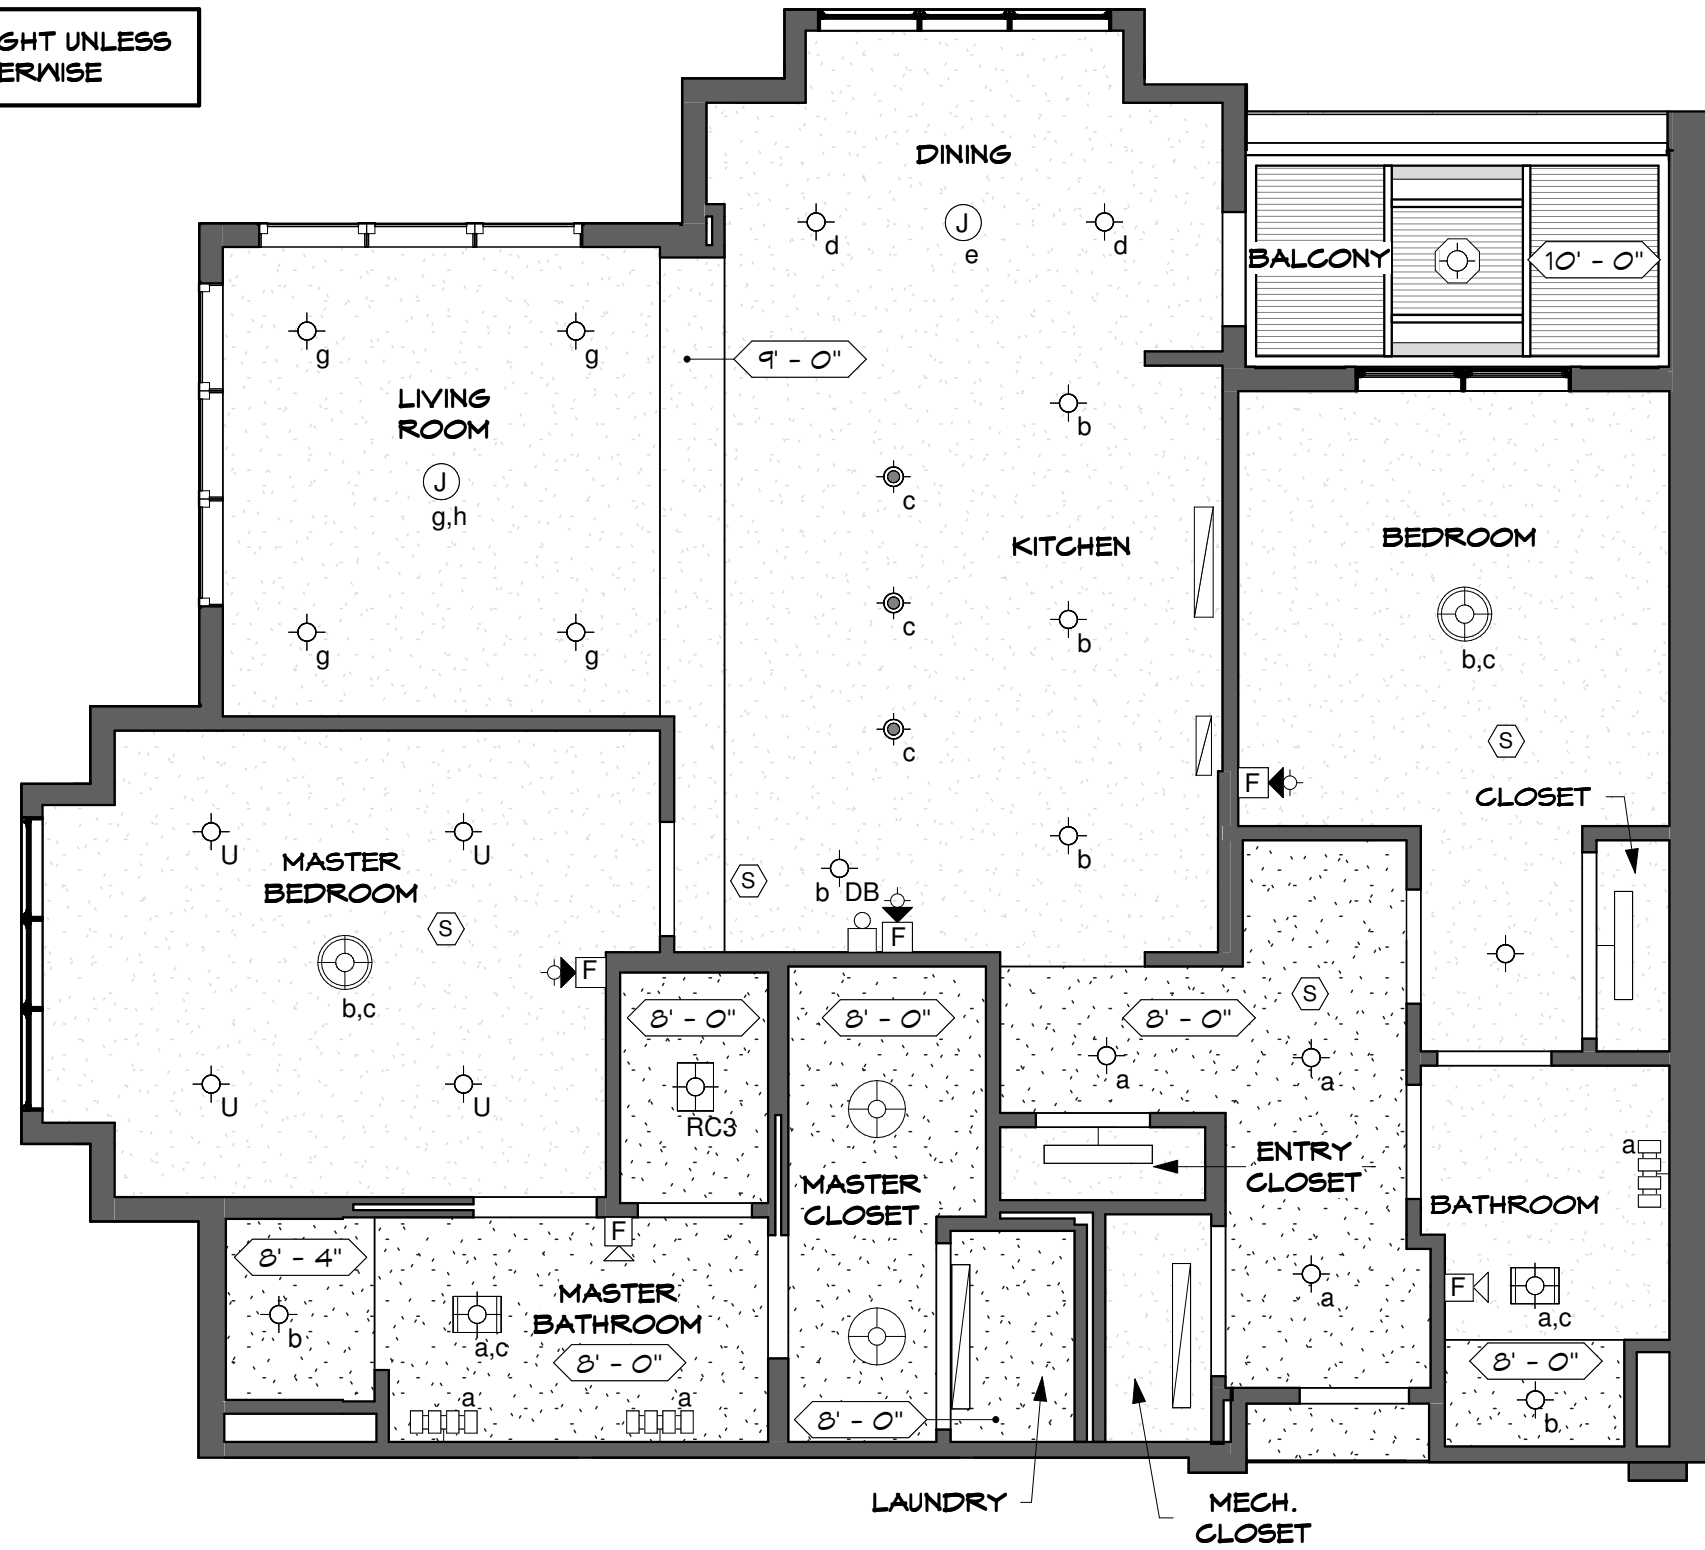


KEY LEGEND

- Ⓝ JUNCTION BOX
- Ⓢ SMOKE DETECTOR
- ⊙ 4" DIAM. SHOWER LIGHT FIXTURE
- ⊙ 6" DIAM. SURFACE MOUNTED LIGHT FIXTURE
- ⊙ 6.5" DIAM. PENDANT LIGHT FIXTURE
- ⊙ 18" DIAM. PENDANT LIGHT FIXTURE
- ⊙ 19" DIAM. PENDANT LIGHT FIXTURE
- ⊙ COMBINATION LIGHT/HEATER/FAN
- ⊙ COMBINATION LIGHT/FAN
- ⊙ VANITY LIGHT BAR (3)
- ⊙ VANITY LIGHT BAR (4)
- ▭ UNDERCABINET LIGHT FIXTURE
- ▭ 36" TROFFER LIGHT FIXTURE
- ▭ 48" TROFFER LIGHT FIXTURE
- ⊙ BALCONY LIGHT FIXTURE
- ⊙ UPGRADE - 6" DIAM. SURFACE MOUNTED LIGHT FIXTURE
- Ⓢ F FIRE ALARM AUDIO/VISUAL DEVICES
- Ⓢ F FIRE ALARM AUDIO DEVICE

MADISON - UNIT 302 REFLECTED CEILING PLAN

SCALE: 3/16"=1'-0"

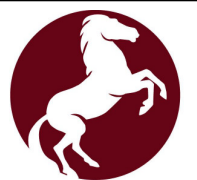

SEARSTONE
RETIREMENT COMMUNITY

APPROVED:
DATE:

MADISON

*FLOOR PLAN
SUBJECT TO CHANGE

SHEET 2 OF 2