 

















 



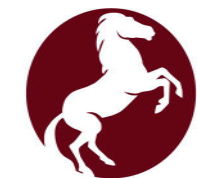
 


KEY LEGEND

-  DUPLEX RECEPTACLE
-  DUPLEX RECEPTACLE TOP HALF SWITCHED
-  GF DUPLEX RECEPTACLE GROUND FAULT
-  FLOOR DUPLEX RECEPTACLE
-  R RANGE RECEPTACLE
-  M MICROWAVE RECEPTACLE
-  W WASHER RECEPTACLE
-  D DRYER RECEPTACLE
-  * DUPLEX RECEPTACLE ABOVE COUNTER
-  J JUNCTION BOX
-  TD TELEPHONE-DATA OUTLET
-  TV TELEVISION-DATA OUTLET
-  T1 TELEPHONE OUTLET
-  DB DOOR BELL-INTERIOR
-  ● DB DOOR BELL
-  RECESSED LOW VOLTAGE PANEL
-  RECESSED ELECTRICAL PANEL
-  S WALL SWITCH
-  S₃ THREE-WAY SWITCH
-  S_{3D} THREE-WAY DIMMER SWITCH
-  CPT. CARPET
-  LVT. LUXURY VINYL TILE

DEMILLE II - UNIT 417 FLOOR PLAN

SCALE: 3/16"=1'-0"



SEARSTONE
RETIREMENT COMMUNITY


APPROVED:
DATE:

DEMILLE

*FLOOR PLAN
SUBJECT TO CHANGE

SHEET 1 OF 2

9'-5" CEILING HEIGHT UNLESS NOTED OTHERWISE

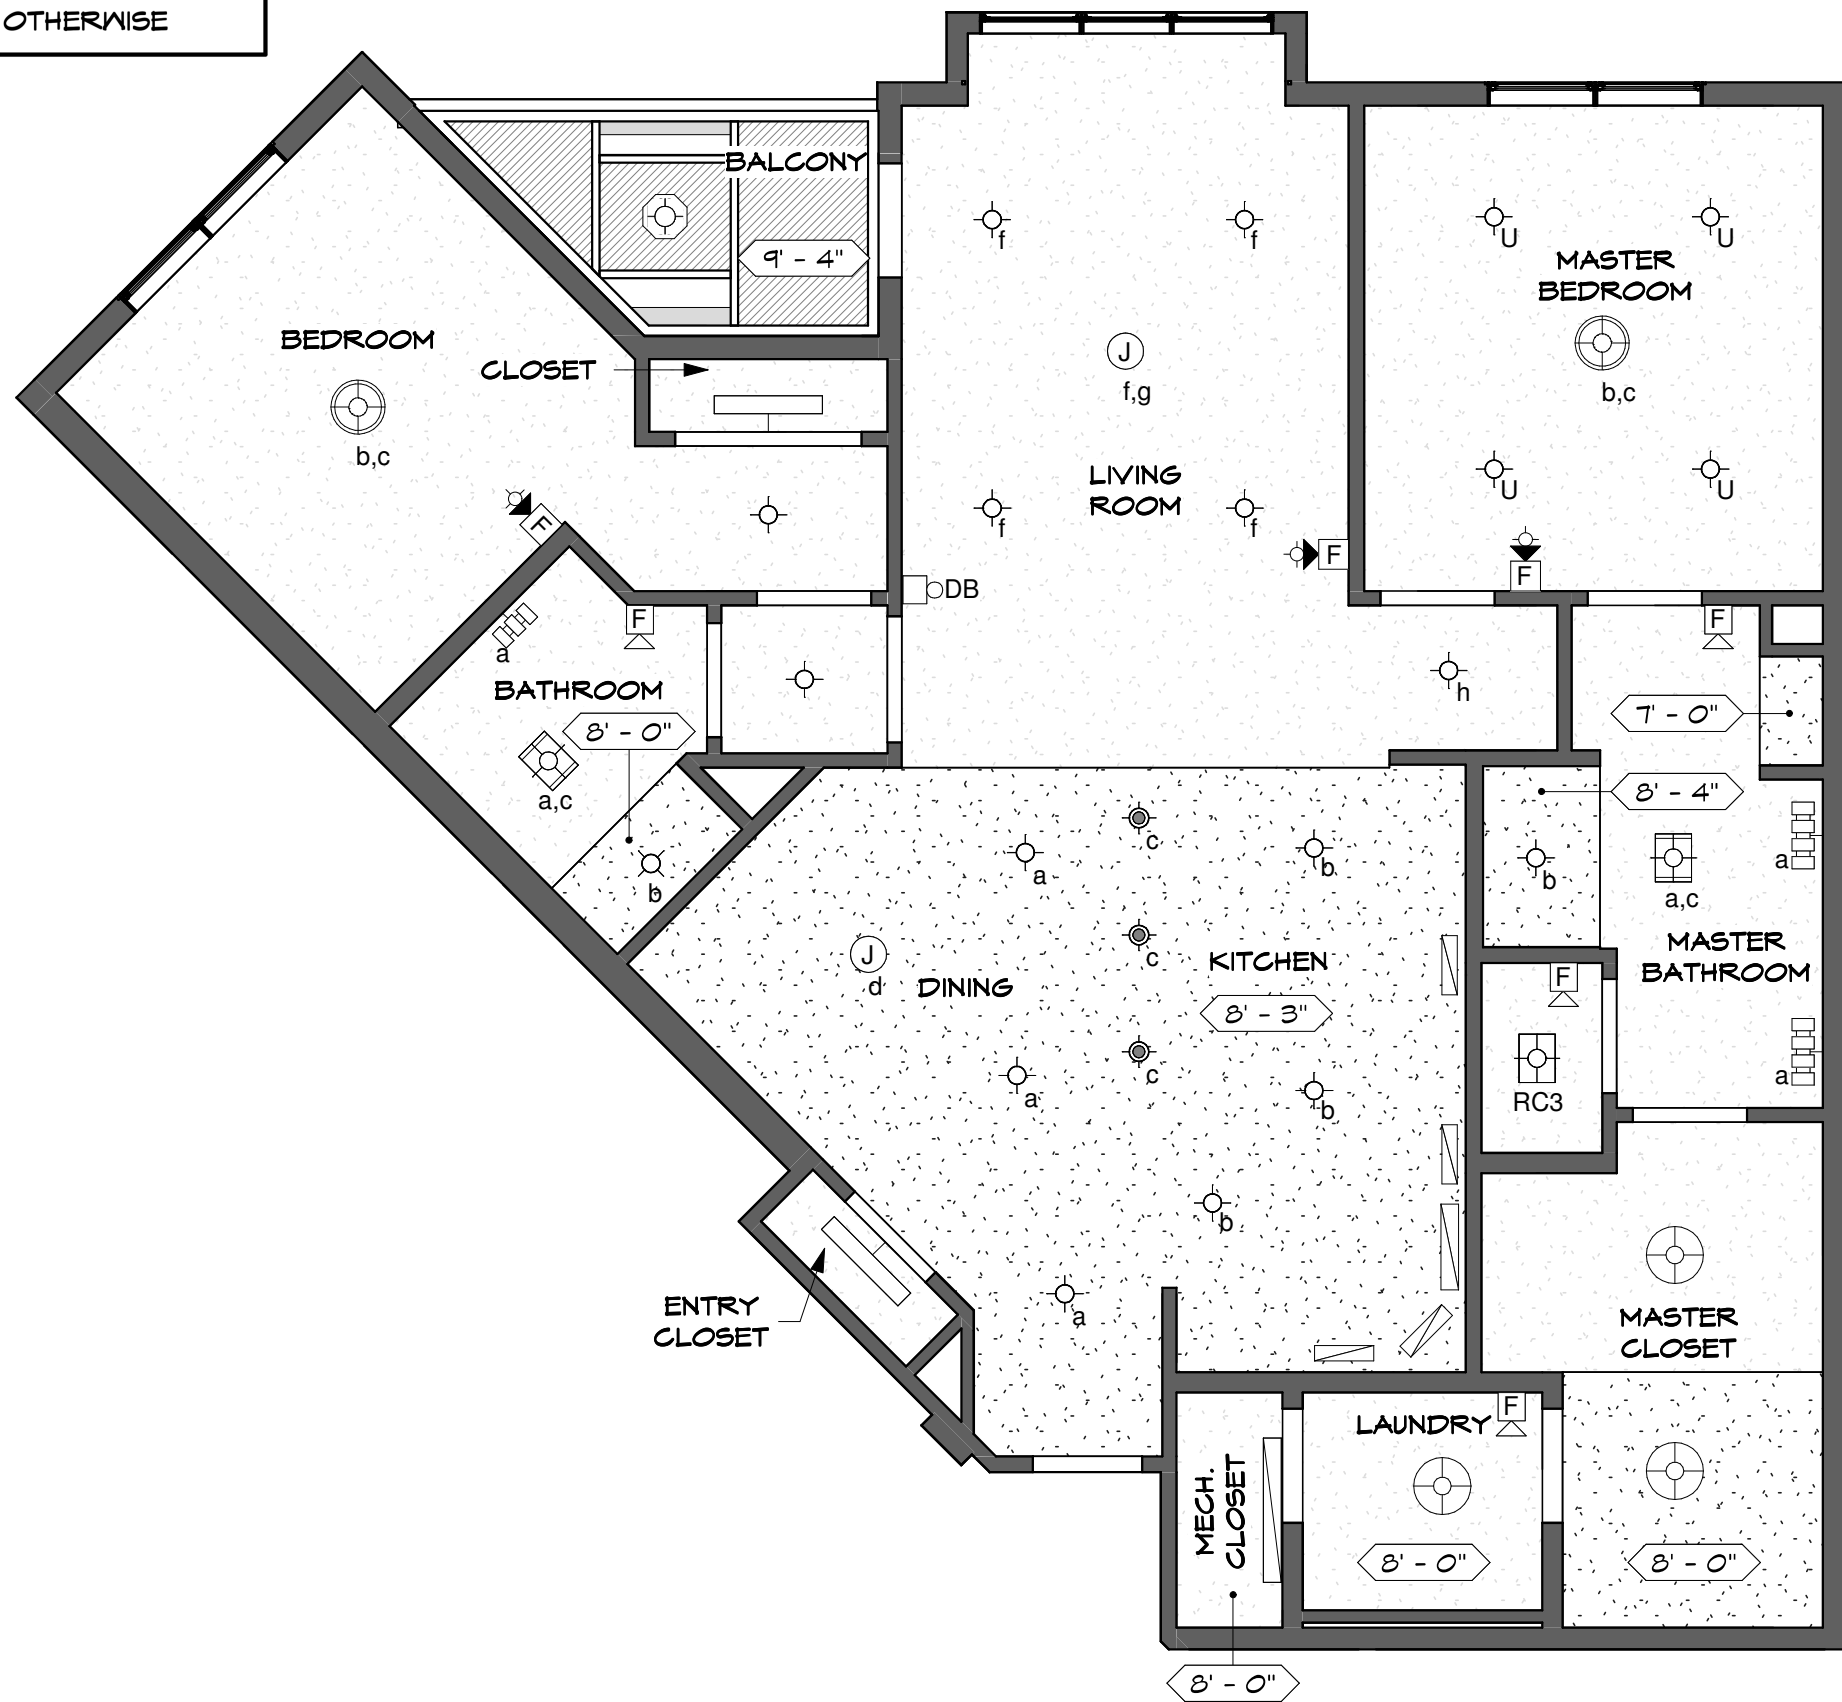


KEY LEGEND

- Ⓝ JUNCTION BOX
- Ⓢ SMOKE DETECTOR
- ⊙ 4" DIAM. SHOWER LIGHT FIXTURE
- ⊙ 6" DIAM. SURFACE MOUNTED LIGHT FIXTURE
- ⊙ 6.5" DIAM. PENDANT LIGHT FIXTURE
- ⊙ 18" DIAM. PENDANT LIGHT FIXTURE
- ⊙ 19" DIAM. PENDANT LIGHT FIXTURE
- ⊙ COMBINATION LIGHT/HEATER/FAN
- ⊙ COMBINATION LIGHT/FAN
- ⊙ VANITY LIGHT BAR (3)
- ⊙ VANITY LIGHT BAR (4)
- ▬ UNDERCABINET LIGHT FIXTURE
- ▬ 36" TROFFER LIGHT FIXTURE
- ▬ 48" TROFFER LIGHT FIXTURE
- ⊙ BALCONY LIGHT FIXTURE
- ⊙ UPGRADE - 6" DIAM. SURFACE MOUNTED LIGHT FIXTURE
- Ⓢ F FIRE ALARM AUDIO/VISUAL DEVICES
- Ⓢ F FIRE ALARM AUDIO DEVICE

DEMILLE II - UNIT 417

REFLECTED CEILING PLAN

 SCALE: 3/16"=1'-0"



SEARSTONE
RETIREMENT COMMUNITY

APPROVED:
DATE:

DEMILLE II

*FLOOR PLAN
SUBJECT TO CHANGE

SHEET 2 OF 2