 


- KEY LEGEND**
- DUPLEX RECEPTACLE
 - DUPLEX RECEPTACLE TOP HALF SWITCHED
 - GF DUPLEX RECEPTACLE GROUND FAULT
 - FLOOR DUPLEX RECEPTACLE
 - R RANGE RECEPTACLE
 - M MICROWAVE RECEPTACLE
 - W WASHER RECEPTACLE
 - D DRYER RECEPTACLE
 - * DUPLEX RECEPTACLE ABOVE COUNTER
 - J JUNCTION BOX
 - TD TELEPHONE-DATA OUTLET
 - TV TELEVISION-DATA OUTLET
 - T1 TELEPHONE OUTLET
 - DB DOOR BELL-INTERIOR
 - DB DOOR BELL
 - RECESSED LOW VOLTAGE PANEL
 - RECESSED ELECTRICAL PANEL
 - S WALL SWITCH
 - S₃ THREE-WAY SWITCH
 - S_{3D} THREE-WAY DIMMER SWITCH
 - CPT. CARPET
 - LVT. LUXURY VINYL TILE


DEMILLE - UNIT 115 FLOOR PLAN
SCALE: 3/16"=1'-0"




 

 

 


 


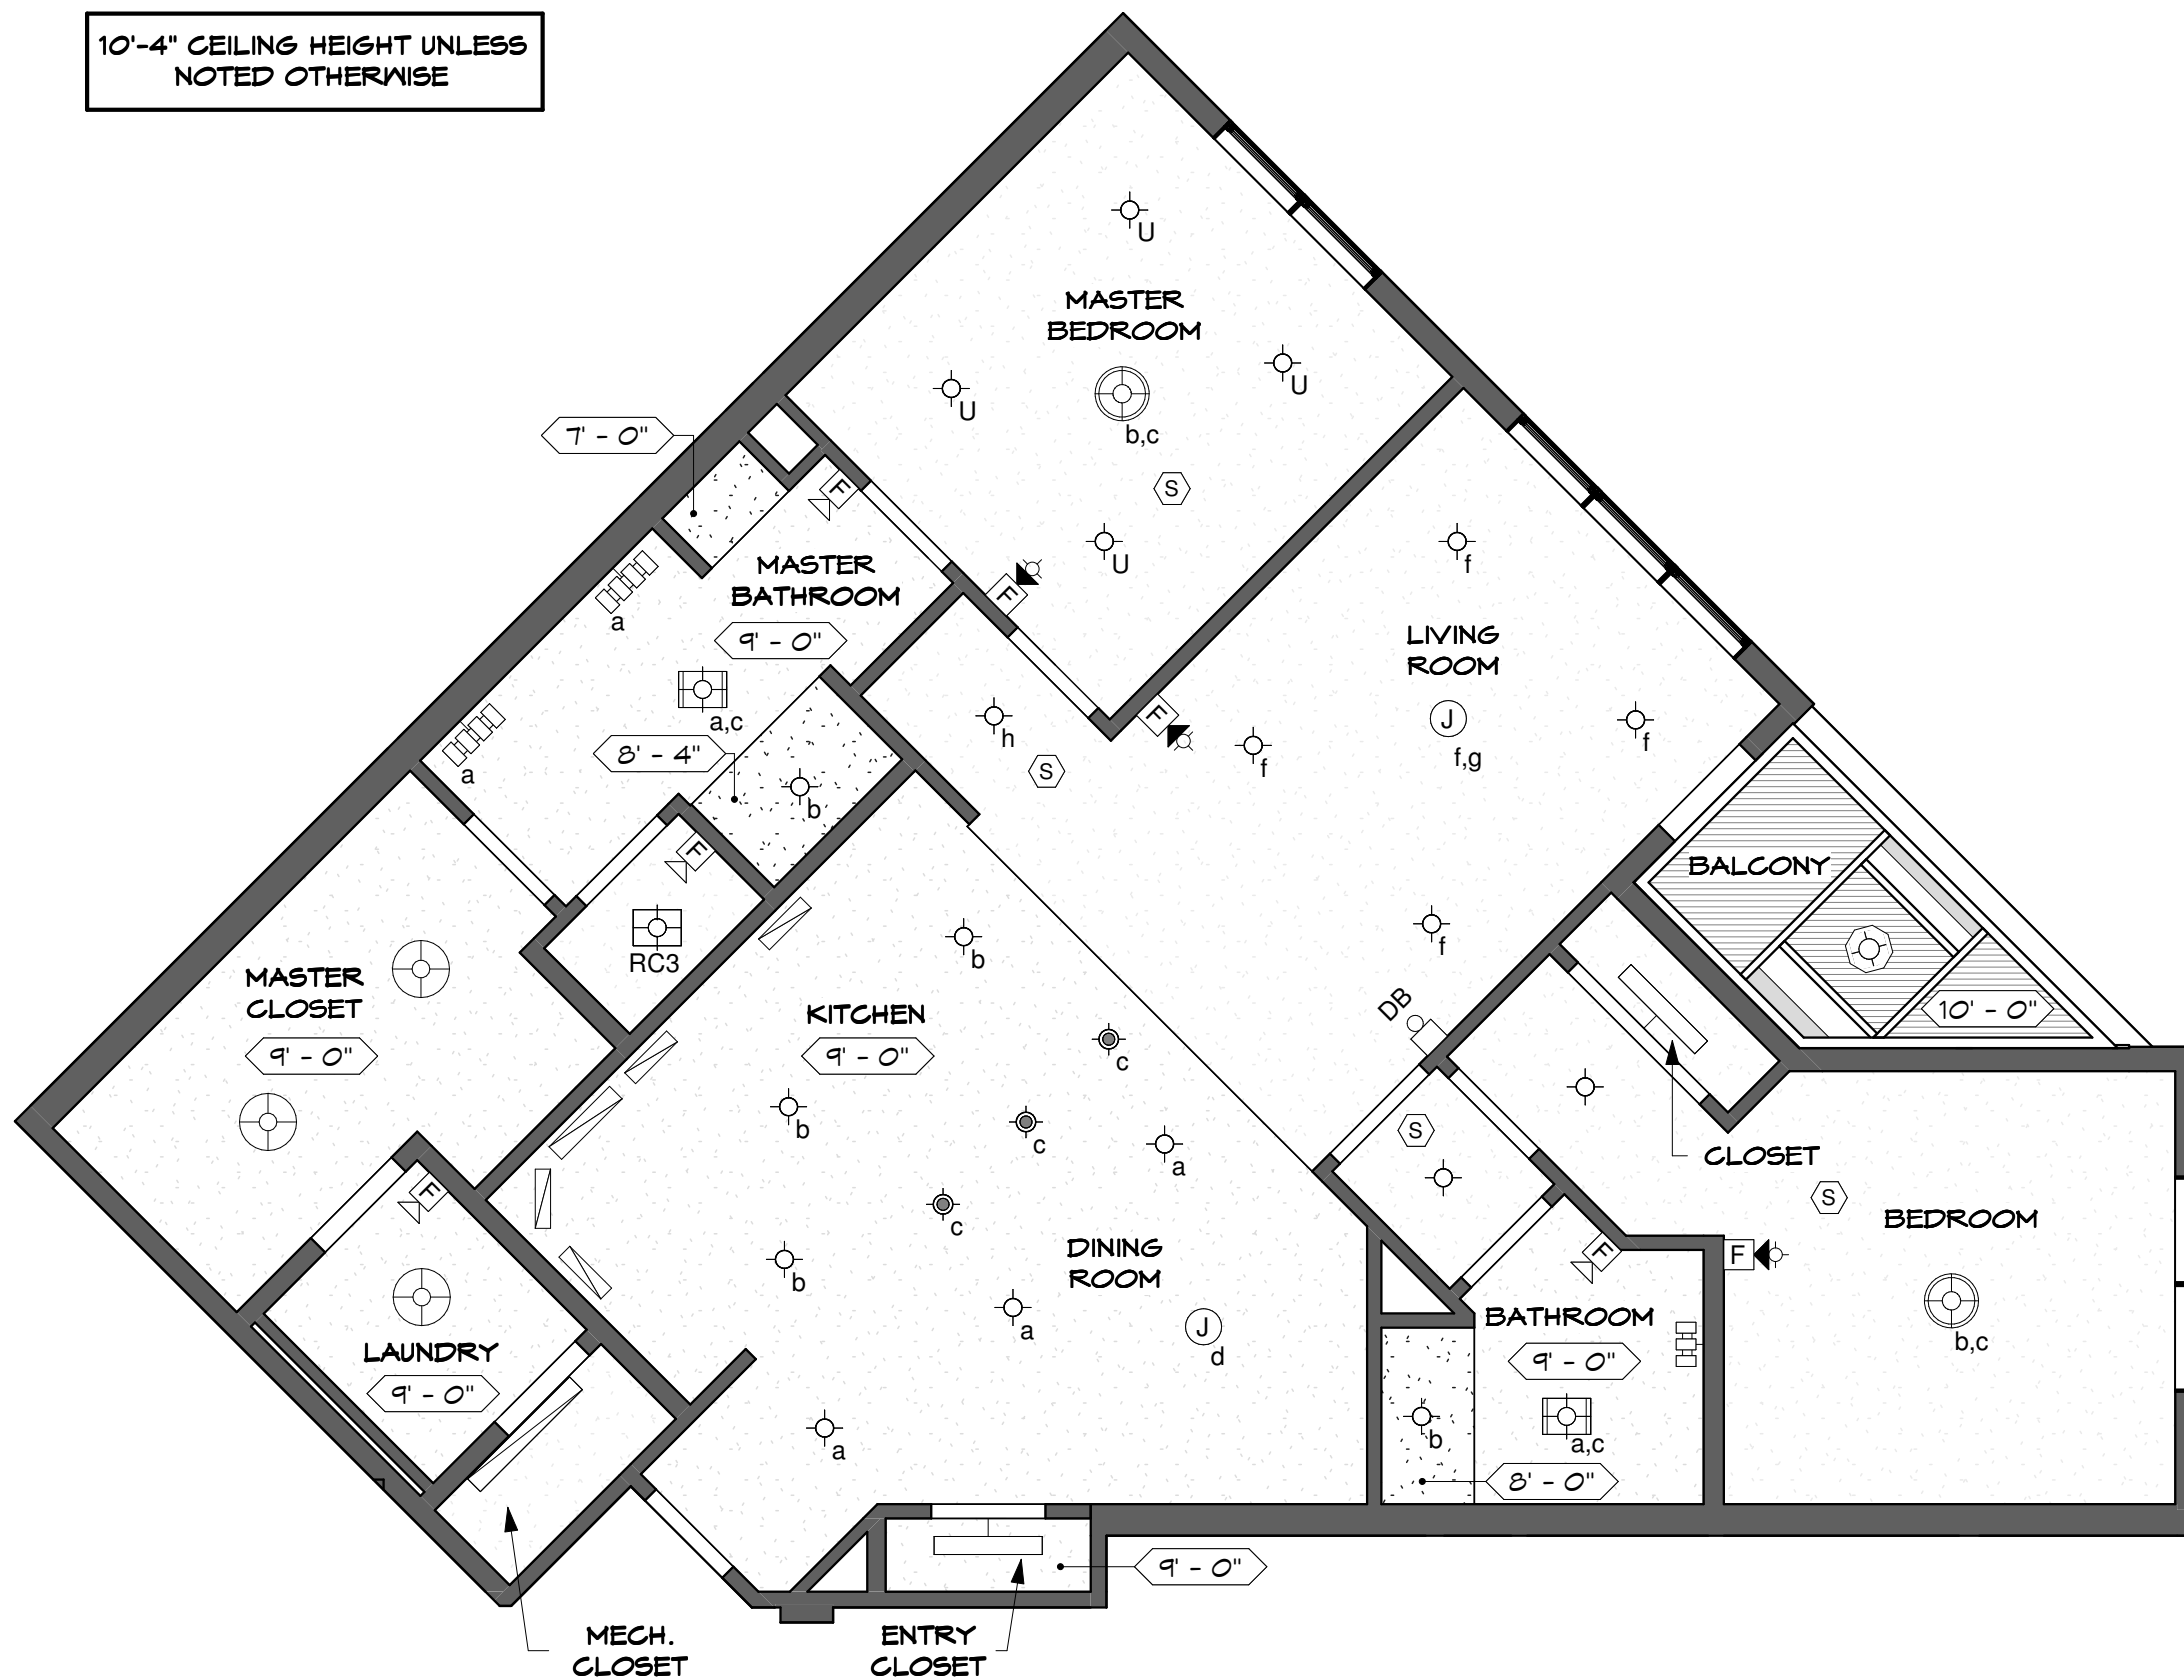


 
 
 
 
SEARSTONE
RETIREMENT COMMUNITY

APPROVED: DATE:	DEMILLE
*FLOOR PLAN SUBJECT TO CHANGE	SHEET 1 OF 2

10'-4" CEILING HEIGHT UNLESS NOTED OTHERWISE


 


KEY LEGEND

-  JUNCTION BOX
-  SMOKE DETECTOR
-  4" DIAM. SHOWER LIGHT FIXTURE
-  6" DIAM. SURFACE MOUNTED LIGHT FIXTURE
-  6.5" DIAM. PENDANT LIGHT FIXTURE
-  18" DIAM. PENDANT LIGHT FIXTURE
-  19" DIAM. PENDANT LIGHT FIXTURE
-  COMBINATION LIGHT/HEATER/FAN
-  COMBINATION LIGHT/FAN
-  VANITY LIGHT BAR (3)
-  VANITY LIGHT BAR (4)
-  UNDERCABINET LIGHT FIXTURE
-  36" TROFFER LIGHT FIXTURE
-  48" TROFFER LIGHT FIXTURE
-  BALCONY LIGHT FIXTURE
-  UPGRADE - 6" DIAM. SURFACE MOUNTED LIGHT FIXTURE
-  FIRE ALARM AUDIO/VISUAL DEVICES
-  FIRE ALARM AUDIO DEVICE

DEMILLE - UNIT 115 REFLECTED CEILING PLAN

SCALE: 3/16"=1'-0"

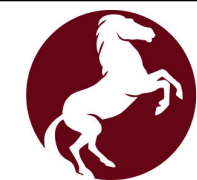

SEARSTONE
RETIREMENT COMMUNITY

APPROVED:
DATE:

DEMILLE

*FLOOR PLAN
SUBJECT TO CHANGE

SHEET 2 OF 2