 

















 



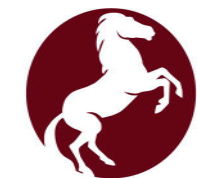


**KEY LEGEND**

-  DUPLEX RECEPTACLE
-  DUPLEX RECEPTACLE TOP HALF SWITCHED
-  GF DUPLEX RECEPTACLE GROUND FAULT
-  FLOOR DUPLEX RECEPTACLE
-  R RANGE RECEPTACLE
-  M MICROWAVE RECEPTACLE
-  W WASHER RECEPTACLE
-  D DRYER RECEPTACLE
-  \* DUPLEX RECEPTACLE ABOVE COUNTER
-  J JUNCTION BOX
-  TD TELEPHONE-DATA OUTLET
-  TV TELEVISION-DATA OUTLET
-  T1 TELEPHONE OUTLET
-  DB DOOR BELL-INTERIOR
-  ● DB DOOR BELL
-  RECESSED LOW VOLTAGE PANEL
-  RECESSED ELECTRICAL PANEL
-  S WALL SWITCH
-  S<sub>3</sub> THREE-WAY SWITCH
-  S<sub>3D</sub> THREE-WAY DIMMER SWITCH
-  CPT. CARPET
-  LVT. LUXURY VINYL TILE

**DEMILLE - UNIT 117 FLOOR PLAN**

SCALE: 3/16"=1'-0"



**SEARSTONE**  
RETIREMENT COMMUNITY


APPROVED:  
DATE:

DEMILLE

\*FLOOR PLAN  
SUBJECT TO CHANGE

SHEET 1 OF 2


10'-4" CEILING HEIGHT UNLESS NOTED OTHERWISE

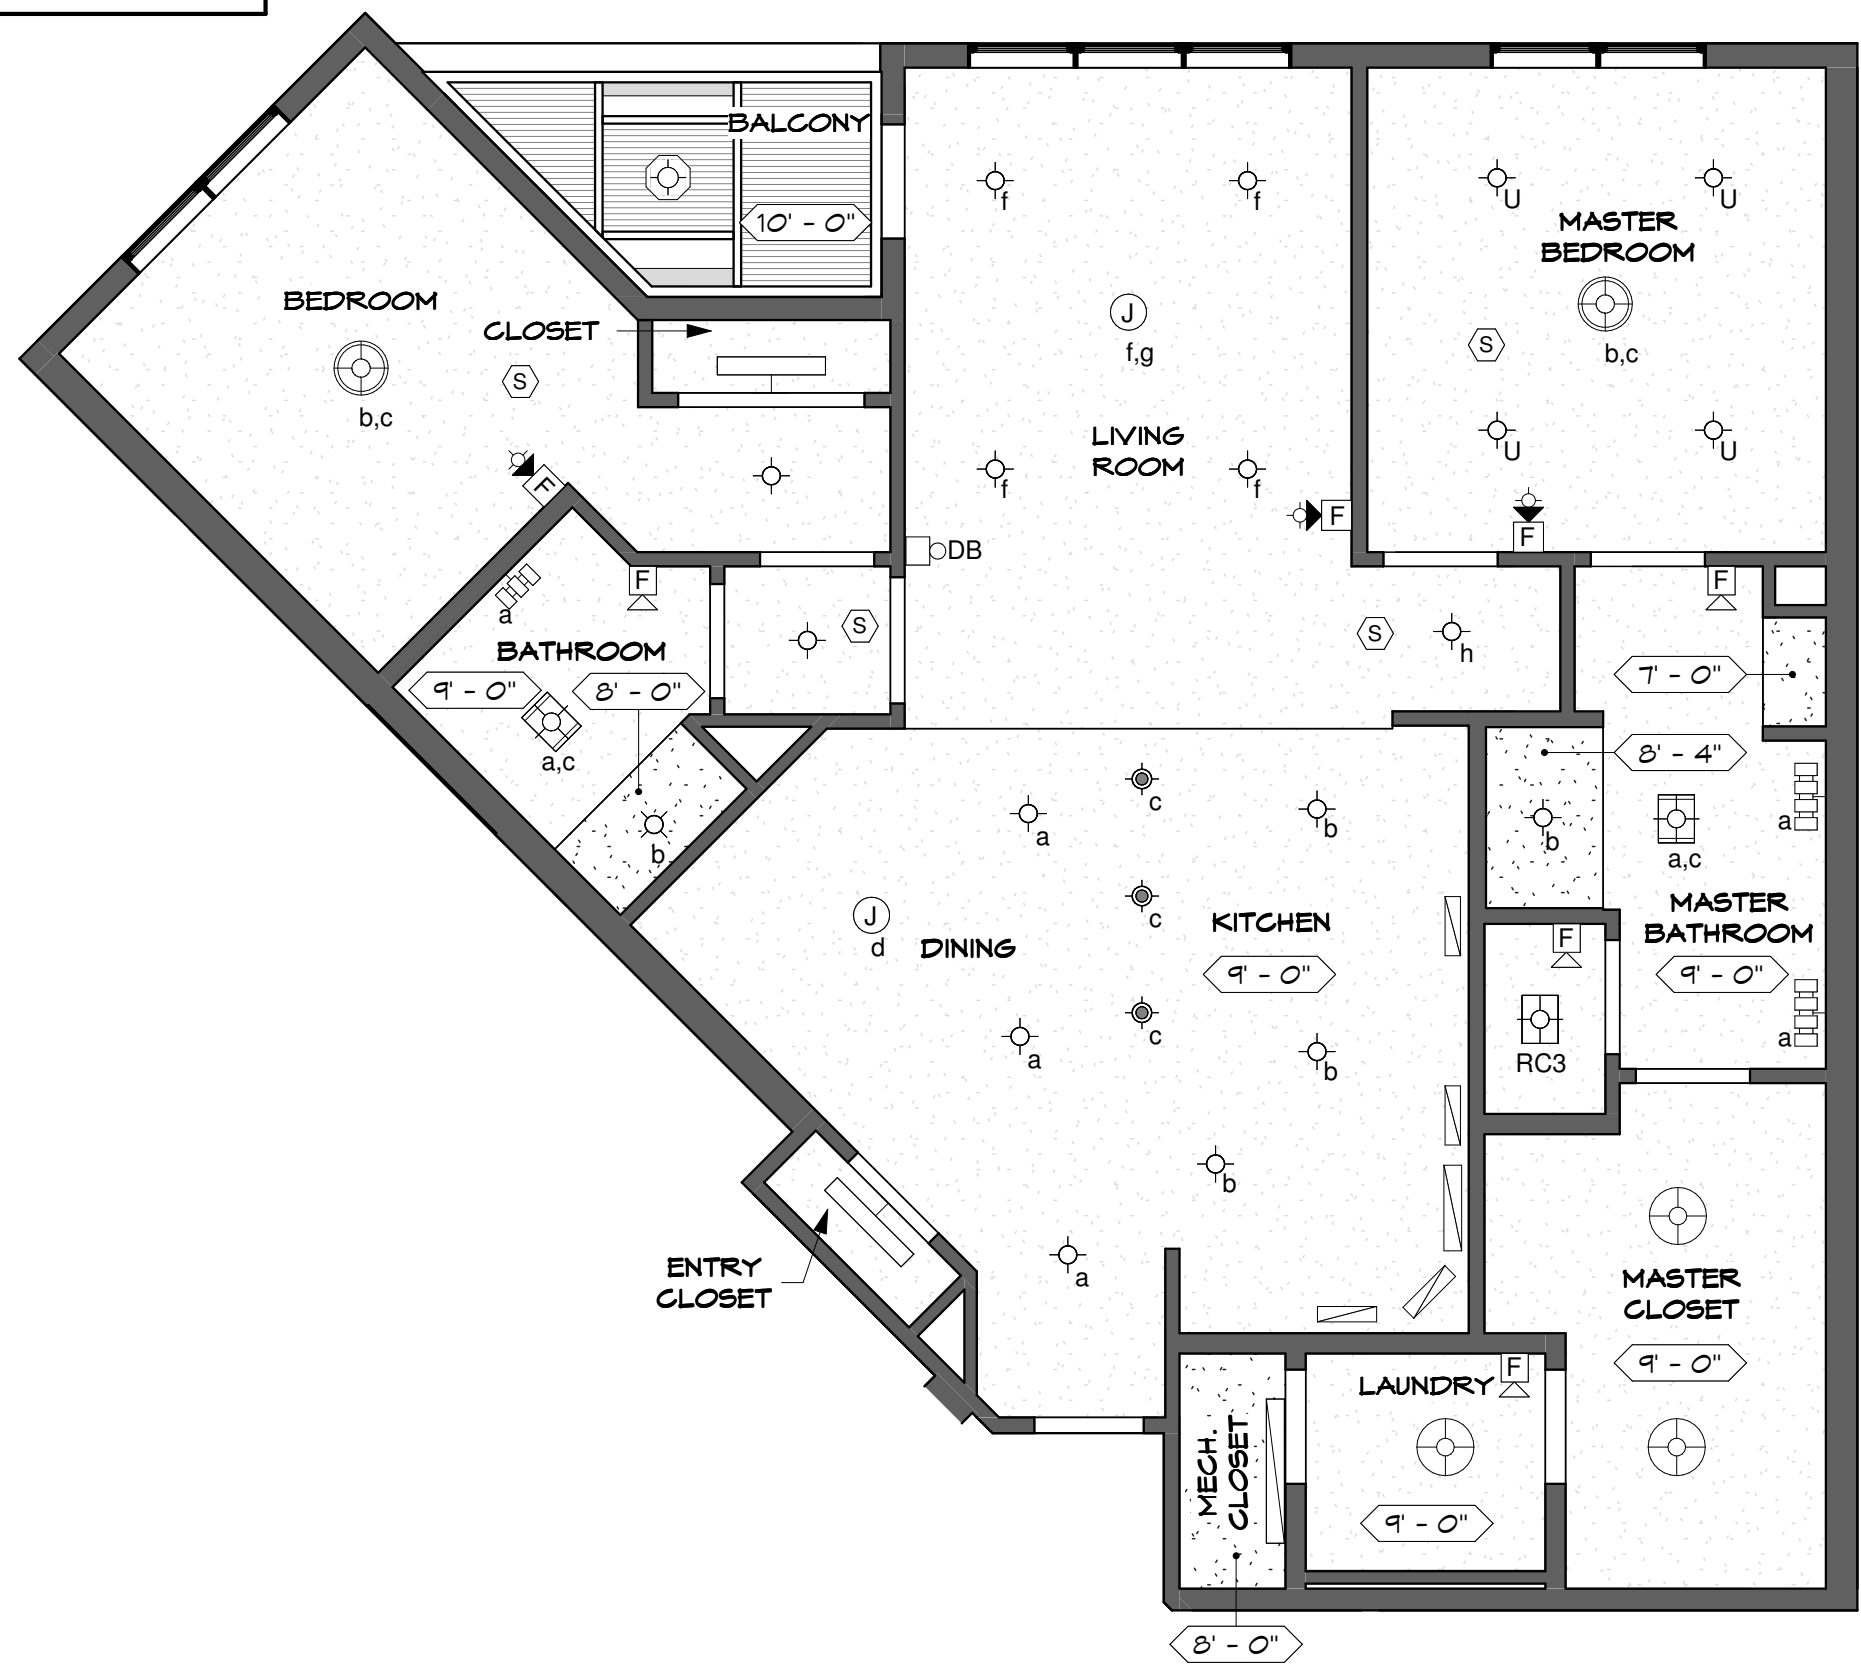

- KEY LEGEND**
- (J) JUNCTION BOX
  - (S) SMOKE DETECTOR
  - ⊙ 4" DIAM. SHOWER LIGHT FIXTURE
  - ⊙ 6" DIAM. SURFACE MOUNTED LIGHT FIXTURE
  - ⊙ 6.5" DIAM. PENDANT LIGHT FIXTURE
  - ⊙ 18" DIAM. PENDANT LIGHT FIXTURE
  - ⊙ 19" DIAM. PENDANT LIGHT FIXTURE
  - ⊙ COMBINATION LIGHT/HEATER/FAN
  - ⊙ COMBINATION LIGHT/FAN
  - ⊙ VANITY LIGHT BAR (3)
  - ⊙ VANITY LIGHT BAR (4)
  - ▬ UNDERCABINET LIGHT FIXTURE
  - ▬ 36" TROFFER LIGHT FIXTURE
  - ▬ 48" TROFFER LIGHT FIXTURE
  - ⊙ BALCONY LIGHT FIXTURE
  - ⊙ UPGRADE - 6" DIAM. SURFACE MOUNTED LIGHT FIXTURE
  - ⊙ FIRE ALARM AUDIO/VISUAL DEVICES
  - ⊙ FIRE ALARM AUDIO DEVICE

**DEMILLE - UNIT 117 REFLECTED CEILING PLAN**

 SCALE: 3/16"=1'-0"



**SEARSTONE**  
RETIREMENT COMMUNITY

APPROVED: DATE:	DEMILLE
*FLOOR PLAN SUBJECT TO CHANGE	SHEET 2 OF 2