













 
 








KEY LEGEND

-  DUPLEX RECEPTACLE
-  DUPLEX RECEPTACLE TOP HALF SWITCHED
-  GF DUPLEX RECEPTACLE GROUND FAULT
-  FLOOR DUPLEX RECEPTACLE
-  R RANGE RECEPTACLE
-  M MICROWAVE RECEPTACLE
-  W WASHER RECEPTACLE
-  D DRYER RECEPTACLE
-  * DUPLEX RECEPTACLE ABOVE COUNTER
-  J JUNCTION BOX
-  TD TELEPHONE-DATA OUTLET
-  TV TELEVISION-DATA OUTLET
-  T1 TELEPHONE OUTLET
-  DB DOOR BELL-INTERIOR
-  DB DOOR BELL
-  RECESSED LOW VOLTAGE PANEL
-  RECESSED ELECTRICAL PANEL
-  S WALL SWITCH
-  S₃ THREE-WAY SWITCH
-  S_{3D} THREE-WAY DIMMER SWITCH
-  CPT. CARPET
-  LVT. LUXURY VINYL TILE

TAYLOR II - UNIT 446 FLOOR PLAN

SCALE: 3/16"=1'-0"



SEARSTONE
RETIREMENT COMMUNITY


APPROVED:
DATE:

TAYLOR II

*FLOOR PLAN
SUBJECT TO CHANGE


SHEET 1 OF 2

9'-5" CEILING HEIGHT UNLESS NOTED OTHERWISE

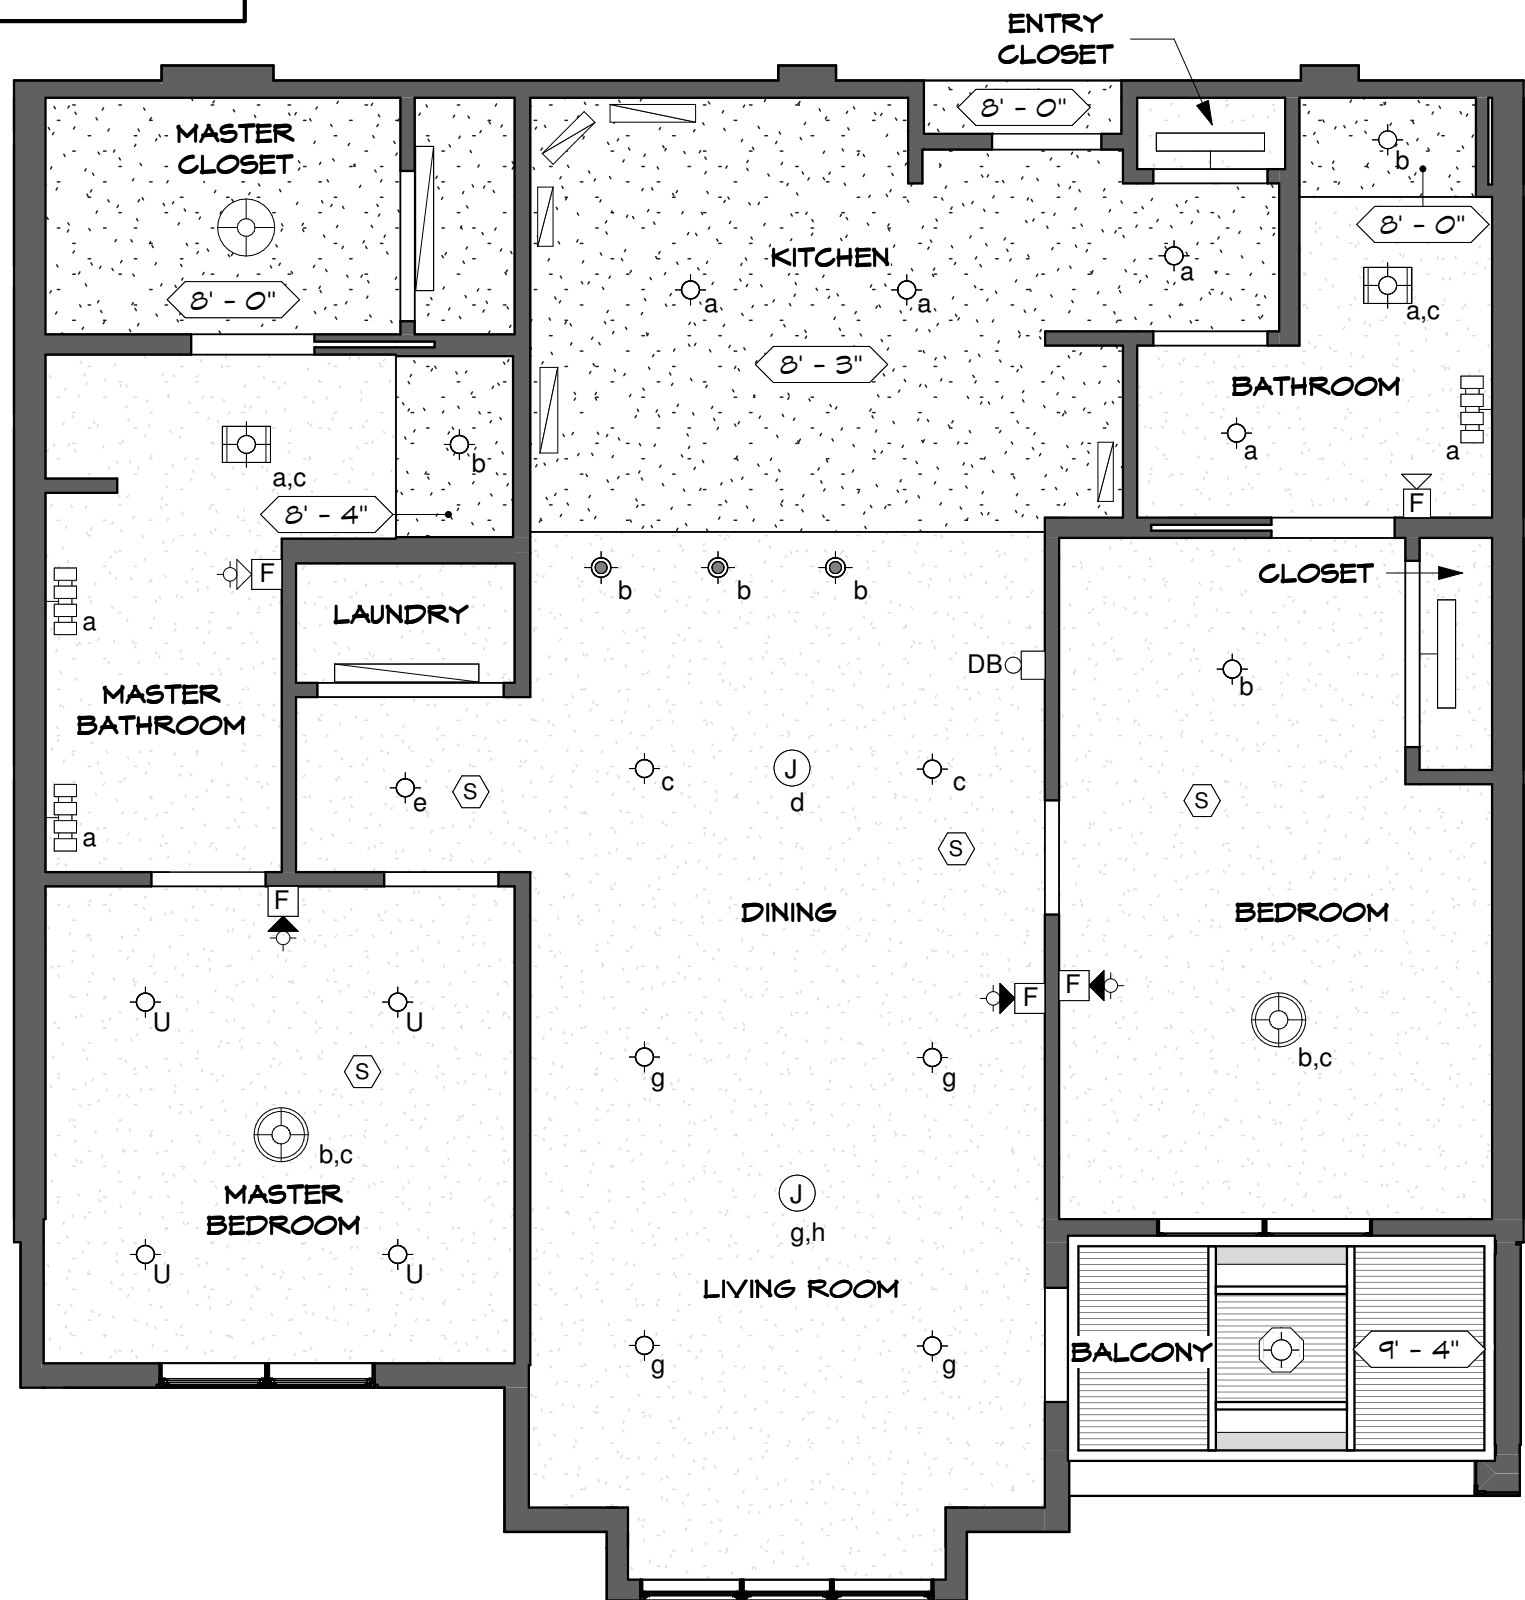

- KEY LEGEND**
- JUNCTION BOX
 - SMOKE DETECTOR
 - 4" DIAM. SHOWER LIGHT FIXTURE
 - 6" DIAM. SURFACE MOUNTED LIGHT FIXTURE
 - 6.5" DIAM. PENDANT LIGHT FIXTURE
 - 18" DIAM. PENDANT LIGHT FIXTURE
 - 19" DIAM. PENDANT LIGHT FIXTURE
 - COMBINATION LIGHT/HEATER/FAN
 - COMBINATION LIGHT/FAN
 - VANITY LIGHT BAR (3)
 - VANITY LIGHT BAR (4)
 - UNDERCABINET LIGHT FIXTURE
 - 36" TROFFER LIGHT FIXTURE
 - 48" TROFFER LIGHT FIXTURE
 - BALCONY LIGHT FIXTURE
 - UPGRADE - 6" DIAM. SURFACE MOUNTED LIGHT FIXTURE
 - FIRE ALARM AUDIO/VISUAL DEVICES
 - FIRE ALARM AUDIO DEVICE

 TAYLOR II - UNIT 446 REFLECTED CEILING PLAN
SCALE: 3/16"=1'-0"



SEARSTONE
RETIREMENT COMMUNITY

APPROVED: DATE:	TAYLOR II
*FLOOR PLAN SUBJECT TO CHANGE	SHEET 2 OF 2