 


- KEY LEGEND**
- DUPLEX RECEPTACLE
  - DUPLEX RECEPTACLE TOP HALF SWITCHED
  - GF DUPLEX RECEPTACLE GROUND FAULT
  - FLOOR DUPLEX RECEPTACLE
  - R RANGE RECEPTACLE
  - M MICROWAVE RECEPTACLE
  - W WASHER RECEPTACLE
  - D DRYER RECEPTACLE
  - \* DUPLEX RECEPTACLE ABOVE COUNTER
  - J JUNCTION BOX
  - TD TELEPHONE-DATA OUTLET
  - TV TELEVISION-DATA OUTLET
  - T1 TELEPHONE OUTLET
  - DB DOOR BELL-INTERIOR
  - DB DOOR BELL
  - RECESSED LOW VOLTAGE PANEL
  - RECESSED ELECTRICAL PANEL
  - S WALL SWITCH
  - S<sub>3</sub> THREE-WAY SWITCH
  - S<sub>3D</sub> THREE-WAY DIMMER SWITCH
  - CPT. CARPET
  - LVT. LUXURY VINYL TILE




 

 


 

 



 
 
 

**ALSTON - UNIT 118** FLOOR PLAN  
SCALE: 3/16"=1'-0"




**SEARSTONE**  
RETIREMENT COMMUNITY

APPROVED: DATE:	ALSTON
*FLOOR PLAN SUBJECT TO CHANGE	SHEET 1 OF 2

**KEY LEGEND**


-  JUNCTION BOX
-  SMOKE DETECTOR
-  4" DIAM. SHOWER LIGHT FIXTURE
-  6" DIAM. SURFACE MOUNTED LIGHT FIXTURE
-  6.5" DIAM. PENDANT LIGHT FIXTURE
-  18" DIAM. PENDANT LIGHT FIXTURE
-  19" DIAM. PENDANT LIGHT FIXTURE
-  COMBINATION LIGHT/HEATER/FAN
-  COMBINATION LIGHT/FAN
-  VANITY LIGHT BAR (3)
-  VANITY LIGHT BAR (4)
-  UNDERCABINET LIGHT FIXTURE
-  36" TROFFER LIGHT FIXTURE
-  48" TROFFER LIGHT FIXTURE
-  BALCONY LIGHT FIXTURE
-  UPGRADE - 6" DIAM. SURFACE MOUNTED LIGHT FIXTURE
-  FIRE ALARM AUDIO/VISUAL DEVICES
-  FIRE ALARM AUDIO DEVICE

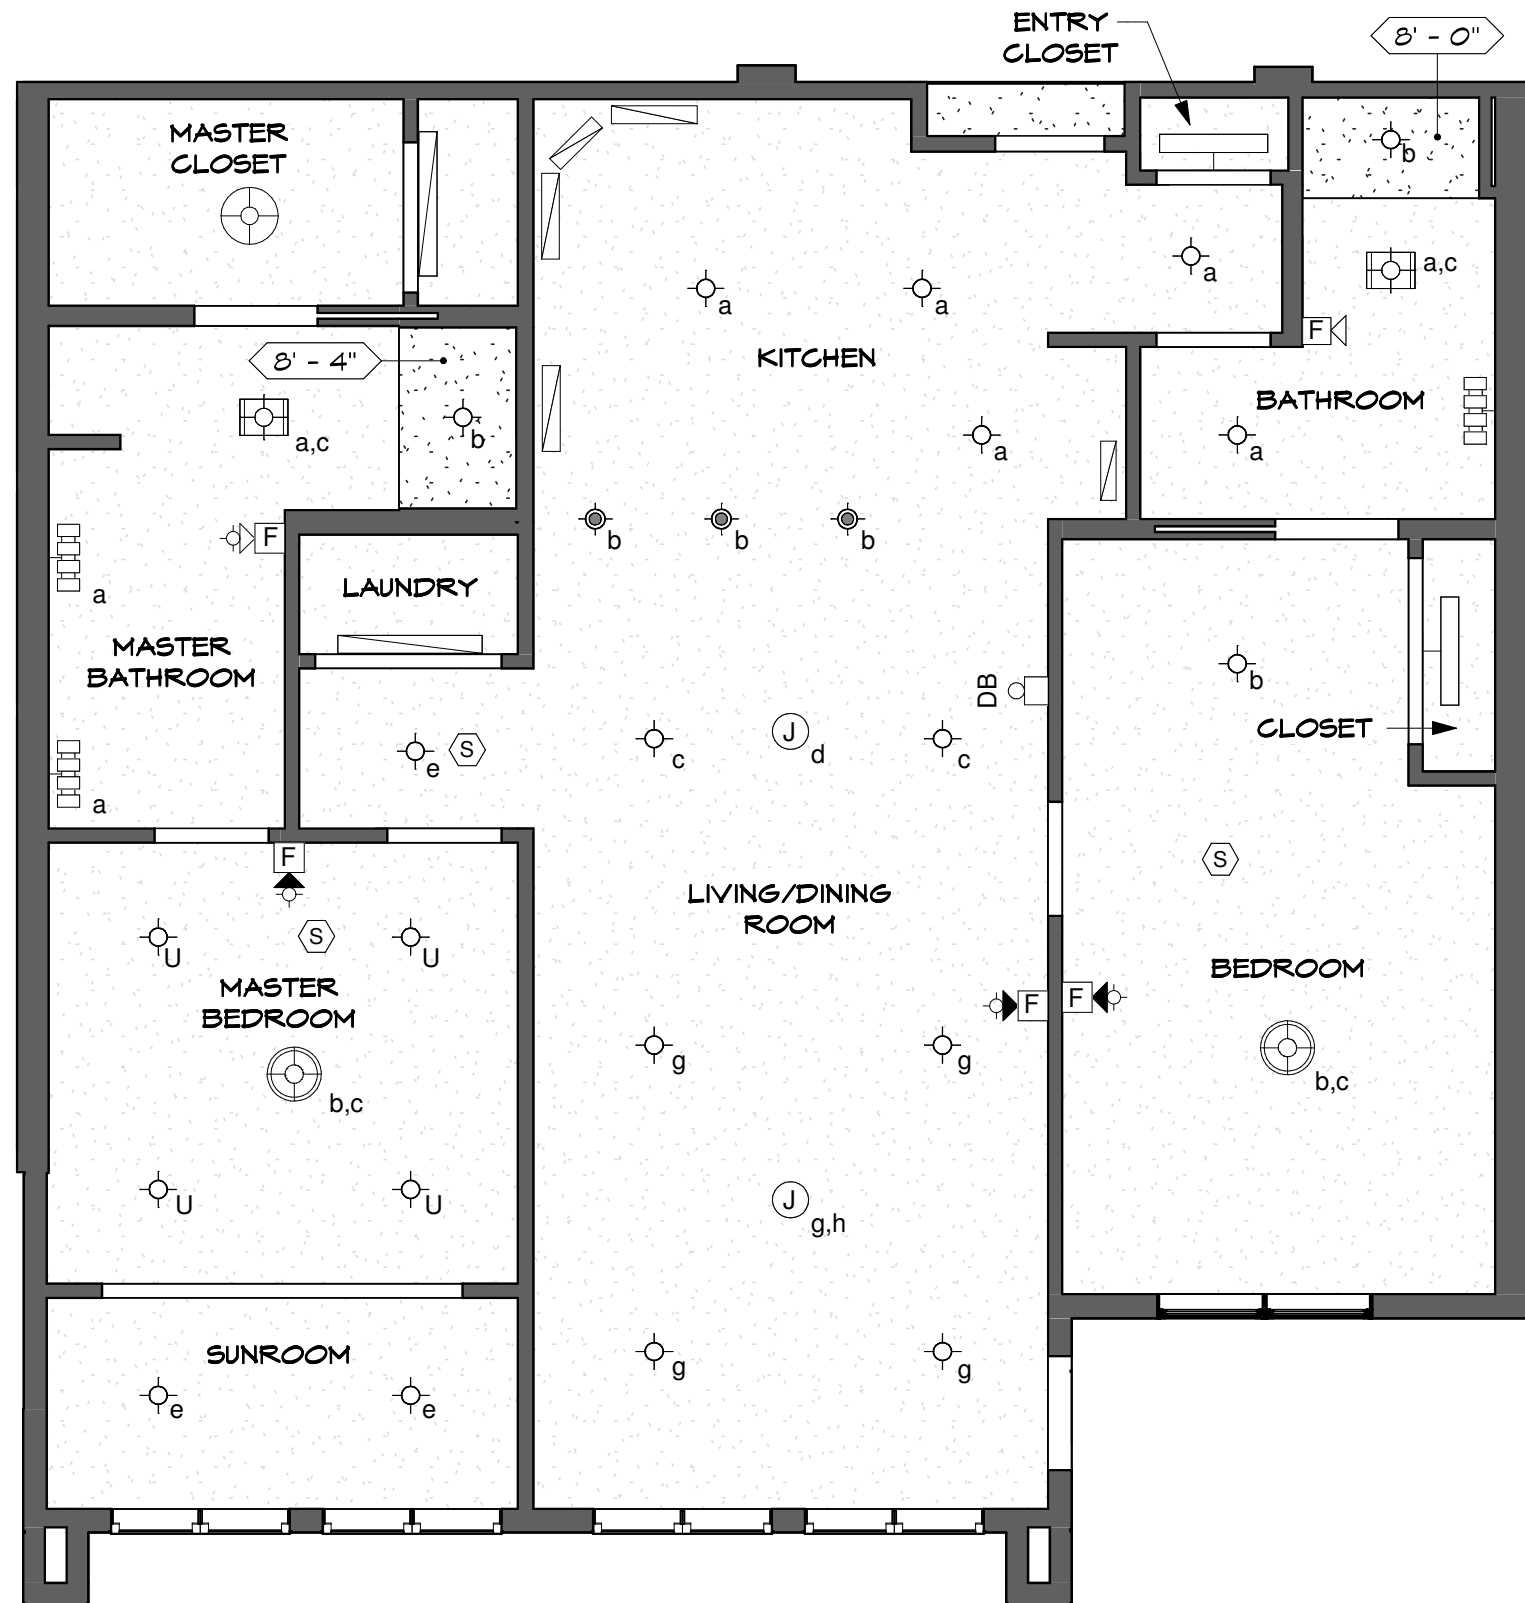

10'-0" CEILING HEIGHT UNLESS NOTED OTHERWISE

**ALSTON - UNIT 118 REFLECTED CEILING PLAN**

SCALE: 3/16"=1'-0"

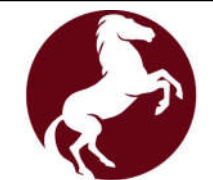

**SEARSTONE**  
RETIREMENT COMMUNITY

APPROVED:  
DATE:  
\*FLOOR PLAN  
SUBJECT TO CHANGE

ALSTON  
SHEET 2 OF 2