













 
 
 



 

 


KEY LEGEND

-  DUPLEX RECEPTACLE
-  DUPLEX RECEPTACLE TOP HALF SWITCHED
-  GF DUPLEX RECEPTACLE GROUND FAULT
-  FLOOR DUPLEX RECEPTACLE
-  RANGE RECEPTACLE
-  MICROWAVE RECEPTACLE
-  WASHER RECEPTACLE
-  DRYER RECEPTACLE
-  DUPLEX RECEPTACLE ABOVE COUNTER
-  JUNCTION BOX
-  TELEPHONE-DATA OUTLET
-  TELEVISION-DATA OUTLET
-  TELEPHONE OUTLET
-  DB DOOR BELL-INTERIOR
-  DB DOOR BELL
-  RECESSED LOW VOLTAGE PANEL
-  RECESSED ELECTRICAL PANEL
-  WALL SWITCH
-  THREE-WAY SWITCH
-  THREE-WAY DIMMER SWITCH
-  CARPET
-  LUXURY VINYL TILE

BRINKLEY - UNIT 209 FLOOR PLAN
SCALE: 3/16"=1'-0"




 

 

 
 

 

 



 
 
 
 



SEARSTONE
RETIREMENT COMMUNITY

APPROVED: DATE:	BRINKLEY
*FLOOR PLAN SUBJECT TO CHANGE	SHEET 1 OF 2

9'-6" CEILING HEIGHT UNLESS NOTED OTHERWISE

KEY LEGEND

-  JUNCTION BOX
-  SMOKE DETECTOR
-  4" DIAM. SHOWER LIGHT FIXTURE
-  6" DIAM. SURFACE MOUNTED LIGHT FIXTURE
-  6.5" DIAM. PENDANT LIGHT FIXTURE
-  18" DIAM. PENDANT LIGHT FIXTURE
-  19" DIAM. PENDANT LIGHT FIXTURE
-  COMBINATION LIGHT/HEATER/FAN
-  COMBINATION LIGHT/FAN
-  VANITY LIGHT BAR (3)
-  VANITY LIGHT BAR (4)
-  UNDERCABINET LIGHT FIXTURE
-  36" TROFFER LIGHT FIXTURE
-  48" TROFFER LIGHT FIXTURE
-  BALCONY LIGHT FIXTURE
-  UPGRADE - 6" DIAM. SURFACE MOUNTED LIGHT FIXTURE
-  FIRE ALARM AUDIO/VISUAL DEVICES
-  FIRE ALARM AUDIO DEVICE

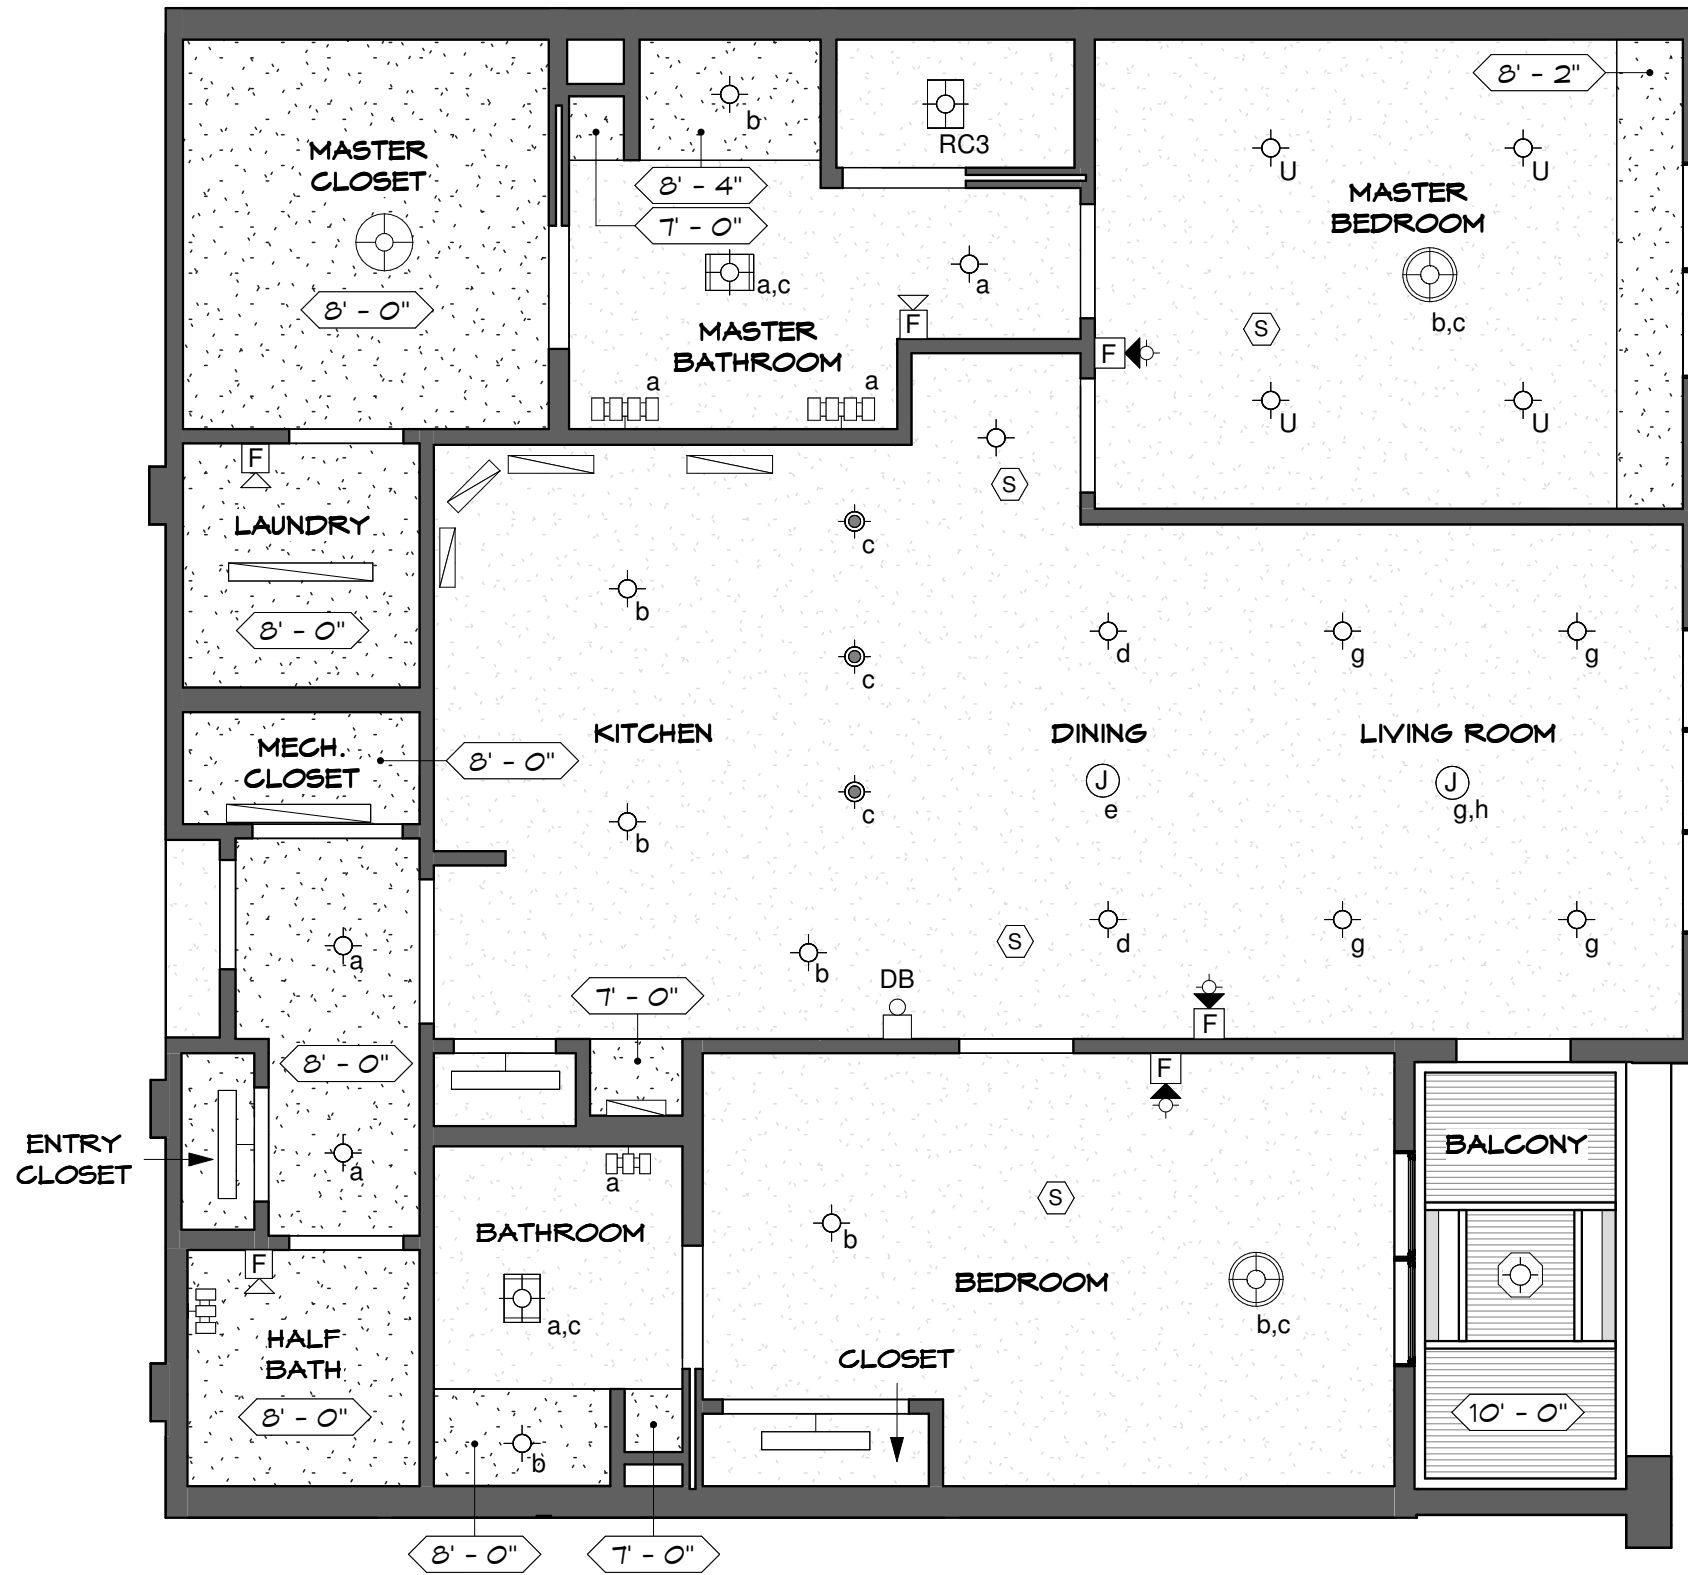

BRINKLEY - UNIT 209 REFLECTED CEILING PLAN

SCALE: 3/16"=1'-0"




APPROVED:
DATE:

BRINKLEY

*FLOOR PLAN
SUBJECT TO CHANGE

SHEET 2 OF 2

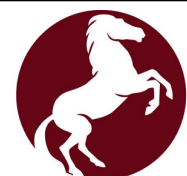

SEARSTONE
RETIREMENT COMMUNITY