 

















 



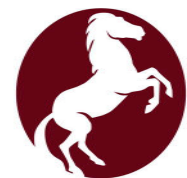
 


KEY LEGEND

-  DUPLEX RECEPTACLE
-  DUPLEX RECEPTACLE TOP HALF SWITCHED
-  GF DUPLEX RECEPTACLE GROUND FAULT
-  FLOOR DUPLEX RECEPTACLE
-  R RANGE RECEPTACLE
-  M MICROWAVE RECEPTACLE
-  W WASHER RECEPTACLE
-  D DRYER RECEPTACLE
-  * DUPLEX RECEPTACLE ABOVE COUNTER
-  J JUNCTION BOX
-  TD TELEPHONE-DATA OUTLET
-  TV TELEVISION-DATA OUTLET
-  T1 TELEPHONE OUTLET
-  DB DOOR BELL-INTERIOR
-  ● DB DOOR BELL
-  RECESSED LOW VOLTAGE PANEL
-  RECESSED ELECTRICAL PANEL
-  S WALL SWITCH
-  S₃ THREE-WAY SWITCH
-  S_{3D} THREE-WAY DIMMER SWITCH
-  CPT. CARPET
-  LVT. LUXURY VINYL TILE

BRINKLEY - UNIT 223 | FLOOR PLAN

SCALE: 3/16"=1'-0"



SEARSTONE
RETIREMENT COMMUNITY


APPROVED:
DATE:

BRINKLEY

*FLOOR PLAN
SUBJECT TO CHANGE

SHEET 1 OF 2

9'-6" CEILING HEIGHT UNLESS NOTED OTHERWISE

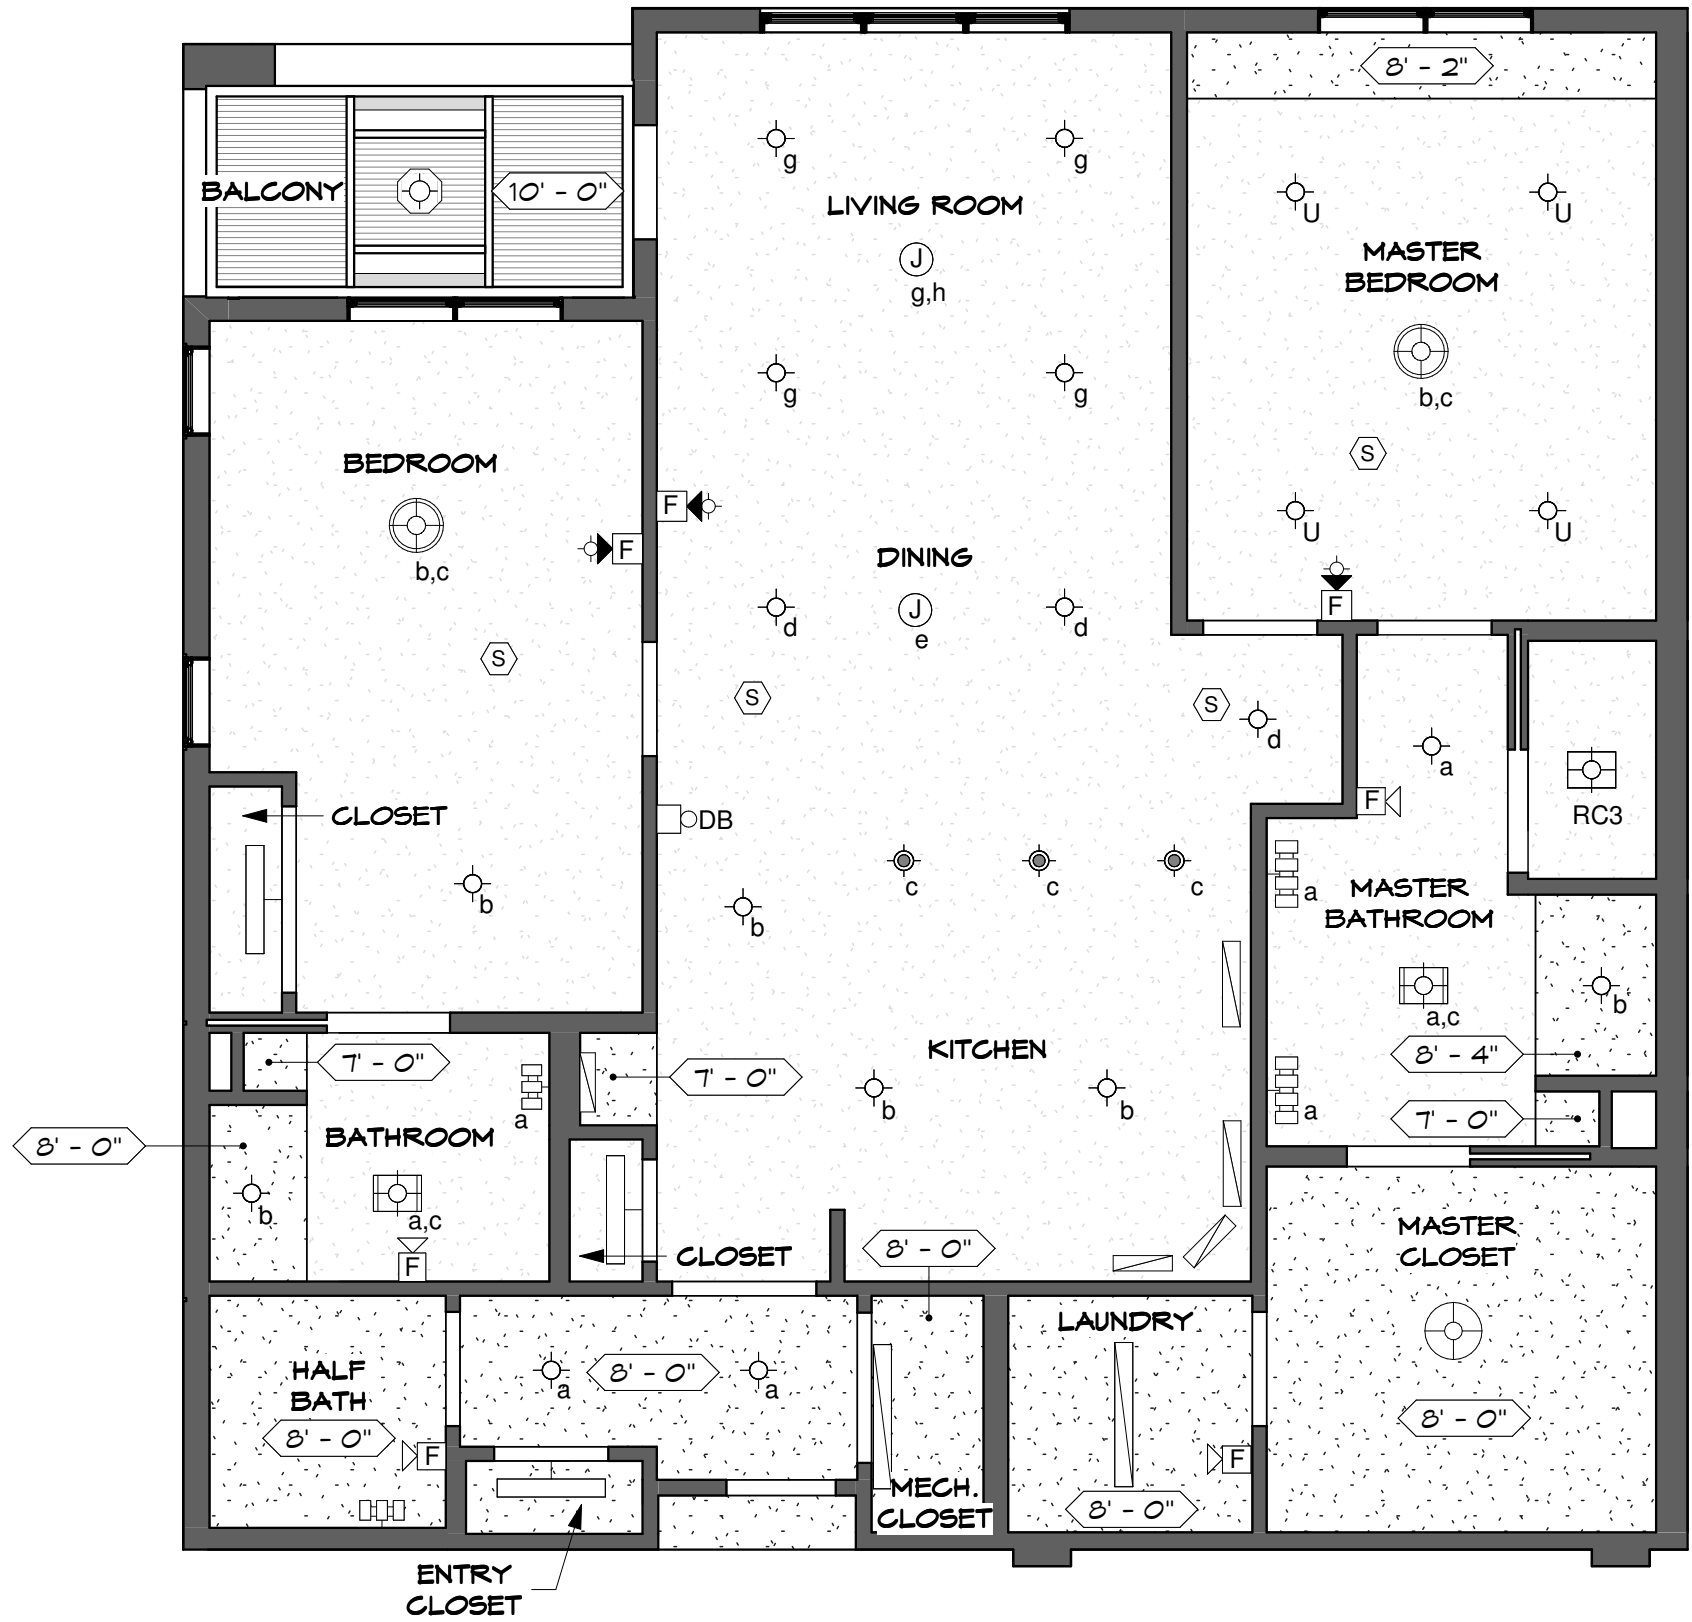

- KEY LEGEND**
- Ⓝ JUNCTION BOX
 - Ⓢ SMOKE DETECTOR
 - ⊙ 4" DIAM. SHOWER LIGHT FIXTURE
 - ⊙ 6" DIAM. SURFACE MOUNTED LIGHT FIXTURE
 - ⊙ 6.5" DIAM. PENDANT LIGHT FIXTURE
 - ⊙ 18" DIAM. PENDANT LIGHT FIXTURE
 - ⊙ 19" DIAM. PENDANT LIGHT FIXTURE
 - ⊙ COMBINATION LIGHT/HEATER/FAN
 - ⊙ COMBINATION LIGHT/FAN
 - ▢ VANITY LIGHT BAR (3)
 - ▢ VANITY LIGHT BAR (4)
 - ▢ UNDERCABINET LIGHT FIXTURE
 - ▢ 36" TROFFER LIGHT FIXTURE
 - ▢ 48" TROFFER LIGHT FIXTURE
 - ⊙ BALCONY LIGHT FIXTURE
 - ⊙ U UPGRADE - 6" DIAM. SURFACE MOUNTED LIGHT FIXTURE
 - Ⓢ F FIRE ALARM AUDIO/VISUAL DEVICES
 - Ⓢ F FIRE ALARM AUDIO DEVICE

BRINKLEY - UNIT 223 REFLECTED CEILING PLAN

SCALE: 3/16"=1'-0"



SEARSTONE
RETIREMENT COMMUNITY

APPROVED: DATE:	BRINKLEY
*FLOOR PLAN SUBJECT TO CHANGE	SHEET 2 OF 2